



CITY OF SOUTH DAYTONA

US 1 UNDERGROUNDING PH 2 - DECORATIVE STREET LIGHTS

BID NO. 25-ITB-017

S RIDGEWOOD AVE (SR5)(RIDGE BLVD TO MCDONALD STREET)

JUNE 2025

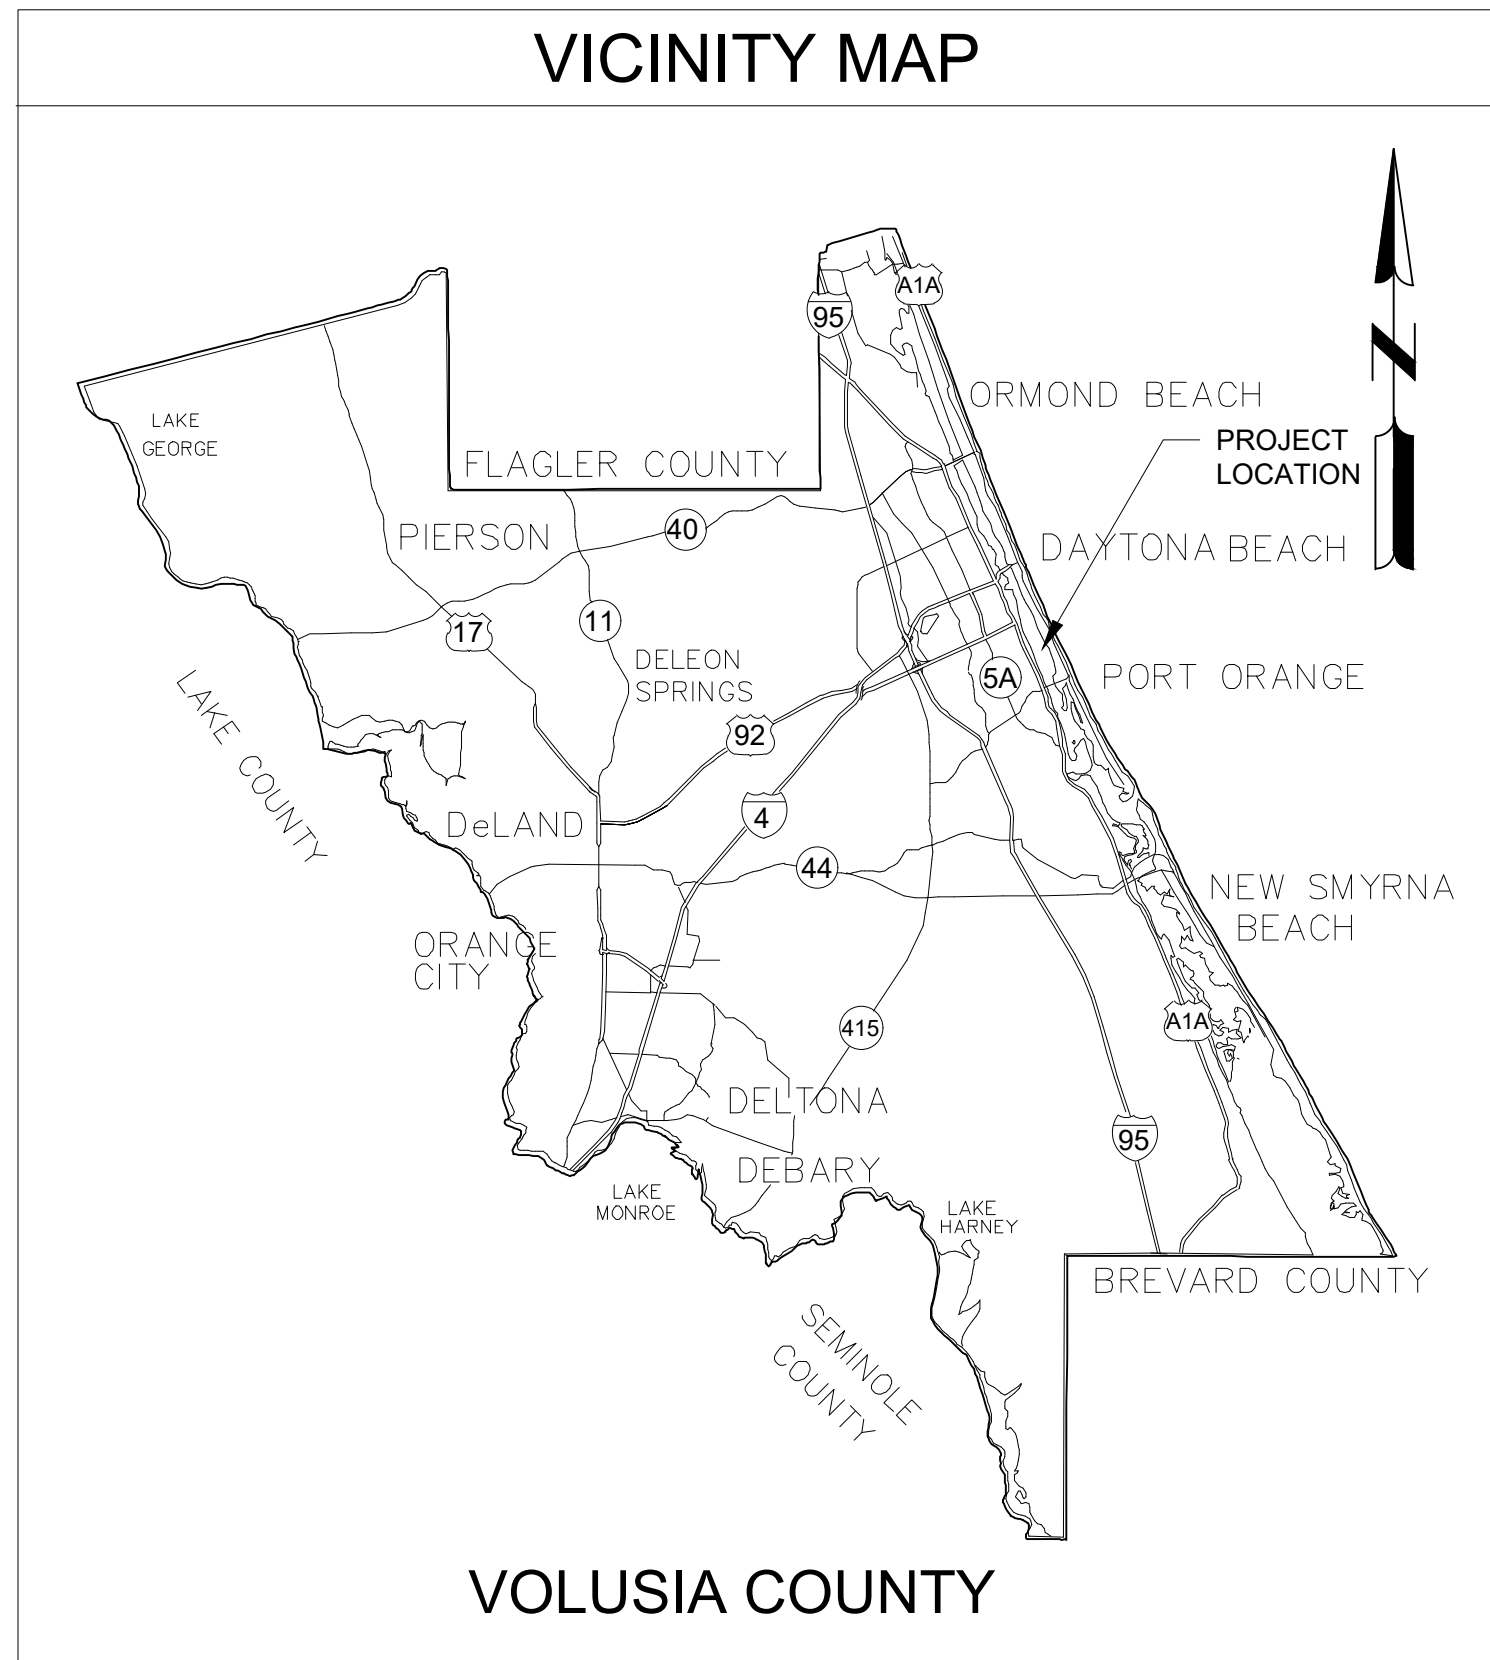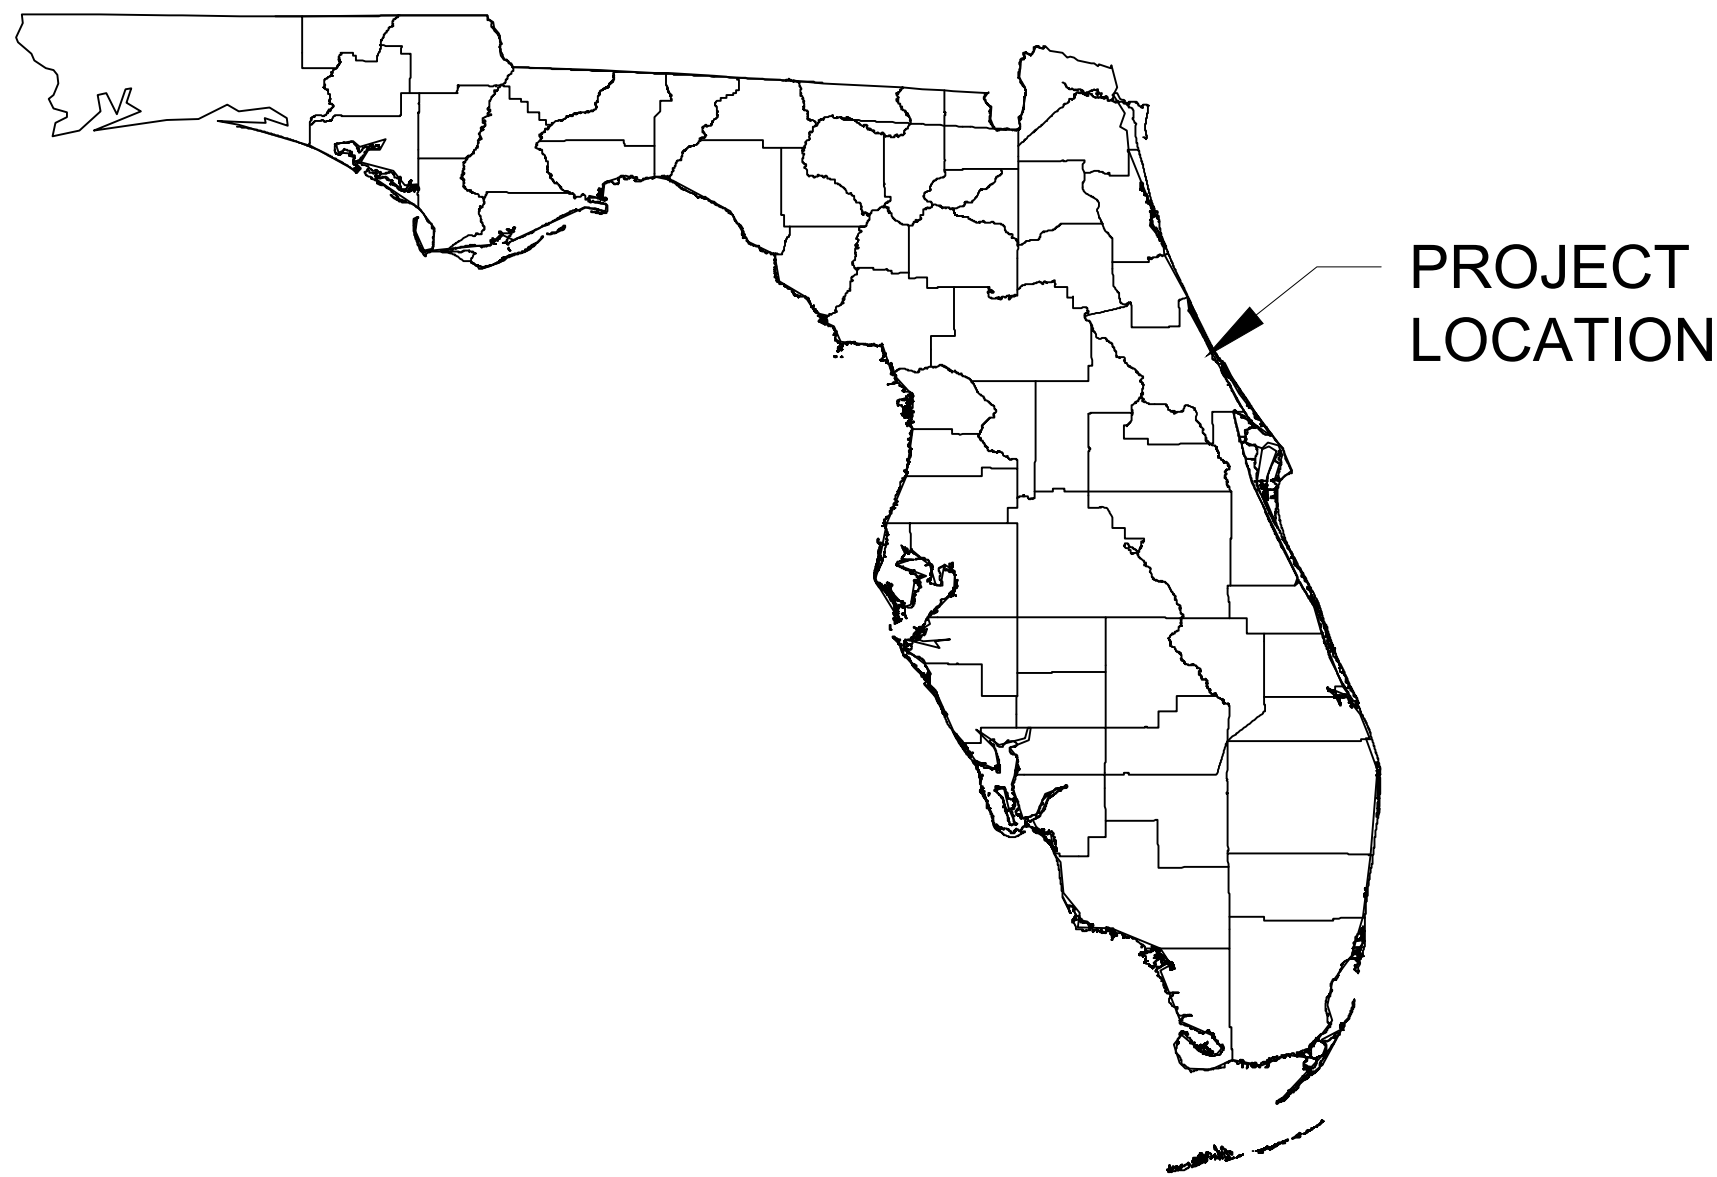

SHEET INDEX

Sheet Number	Sheet Title
G-001	COVER SHEET
G-002	KEY SHEET
C-100	LIGHT POLES
C-101	LIGHT POLES
C-102	LIGHT POLES
C-103	LIGHT POLES
C-110	LIGHTING DETAILS
C-111	MOT DETAILS
C-112	MOT DETAILS
P-200	PHOTOMETRICS
P-201	PHOTOMETRICS
P-202	PHOTOMETRICS
P-203	PHOTOMETRICS
FPL UNDERGROUNDING PLANS (7 SHEETS)	

PROJECT TEAM:

OWNER:

CITY OF SOUTH DAYTONA
CONTACT: JOSH MCENANY
TITLE: ECONOMIC DEVELOPMENT
DIRECTOR
ADDRESS: 1672 S RIDGEWOOD AVE
SOUTH DAYTONA, FL 32119
PHONE: (386)-322-3025

LIGHTING ENGINEER:

MEAD & HUNT, INC.
CONTACT: MURAT JENIDI, P.E.
1111 LIGHT STREET, SUITE 200B
BALTIMORE, MD 21230
PHONE: (407)-923-9557

CIVIL ENGINEER:

MEAD & HUNT, INC.
CONTACT: DAVID KING, P.E.
PROJECT MANAGER
4401 EASTPORT PARKWAY
PORT ORANGE, FL 32127
PHONE: (386)-547-7362

SURVEYOR:

SOUTHEASTERN SURVEYING
& MAPPING
CONTACT: ALEX JENKINS
550 SOUTH HIGHLAND STR
MOUNT DORA, FL 32778
PHONE: (850)-559-1828



Know what's below.
Call before you dig.

Mead
& Hunt

Mead and Hunt, Inc.
4401 Eastport Parkway
Port Orange, FL 32127
phone: 386-761-6810
meadhunt.com
FL Cert. #26730



© Copyright 2025 Mead & Hunt, Inc.
This document, or any portion thereof, shall
not be duplicated, disclosed, or used on any
other project or extension of this project
except by written agreement with Mead &
Hunt, Inc. Mead & Hunt shall not be
responsible for any unauthorized use of, or
alteration to these documents.

CITY OF SOUTH DAYTONA
US-1 UNDERGROUNDING
PH 2

S RIDGEWOOD AVE
SOUTH DAYTONA, FL 32119

ISSUED

NOT FOR CONSTRUCTION

M&H NO.: 1000717-222018.01
DATE: JUNE 2025
DESIGNED BY: RJG
DRAWN BY: RJG
CHECKED BY: DAK
DO NOT SCALE DRAWINGS


SHEET CONTENTS
COVER SHEET

SHEET NO.

G-001



1. EXISTING STREETLIGHTS TO BE REMOVED BY FPL WITH UTILITY UNDERGROUNDING PROJECT.
2. INSTALLATION OF NEW DECORATIVE STREETLIGHTS IS TO BE COORDINATED WITH FPL OVERHEAD ELECTRIC FACILITIES REMOVAL.
3. NEW DECORATIVE STREETLIGHT AND FPL OVERHEAD ELECTRIC FACILITIES REMOVAL WORK SHALL BE CONDUCTED ON ONE SIDE OF US1 AT A TIME SO TO ALLOW EXISTING LIGHTING TO REMAIN ACTIVE ON OPPOSITE SIDE OF US1 WHILE NEW DECORATIVE STREETLIGHTS ARE INSTALLED AND ACTIVATED.
4. ALL NEW DECORATIVE STREETLIGHTS WILL BE SERVED BY INDIVIDUAL UNDERGROUND UN-METERED FPL SERVICES LOCATED OUTSIDE FOOT R/W IN EXISTING UTILITY EASEMENT.
5. CITY OF SOUTH DAYTONA TO OWN AND OPERATE NEW DECORATIVE STREETLIGHTS.
6. NEW DECORATIVE STREETLIGHTS TO MATCH EXISTING DECORATIVE STREETLIGHTS NORTH OF MCDONALD STREET.

UTILITY INFORMATION PROVIDED TO OR COLLECTED BY MEAD & HUNT DURING DESIGN										
UTILITY TYPE	UTILITY COMPANY	CONTACT	PHONE	EMAIL	PRELIMINARY PLANS PROVIDED TO UTILITY	INFORMATION QUALITY LEVEL AND DATE RECEIVED				FINAL PLANS PROVIDED TO UTILITY
						LEVEL A/4	LEVEL B/3	LEVEL C/2	LEVEL D/1	
WATER/WASTEWATER	CITY OF SOUTH DAYTONA	BRIAN PEEK								
FIBER	CHARTER	GARY BLEVINS	(813) 302-0800	gary.blevins@charter.com	3/24/2025					
FIBER	UNITI FIBER LLC	ZACH OLIVER	(251) 214-7059	ZACH.OLIVER@UNITI.COM	3/24/2025					3/24/2025
FIBER	LUMEN	LUMEN CENTURYLINK	(877) 366-8344 x2	relocations@lumen.com	3/24/2025					3/25/2025
FIBER	FPL - NORTH FIBER	DANIEL PEREZ	(305) 586-9748	Daniel.Perez@fpl.com	3/24/2025					
ELECTRIC	FPL - VOLUSIA	JAMIE PURNELL	(386) 586-6403	Jamie.Purnell@fpl.com	3/24/2025					
TELEPHONE	ATT	DINO FARRUGGIO		G27896@ATT.COM	3/24/2025					
GAS	TECO PEOPLE'S GAS- DAYTONA	CHEYENNE THOMPSON	(813) 743-7164	CThompson2@tecoenergy.com	3/24/2025					

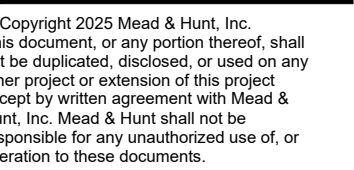

S RIDGEWOOD AVE
SOUTH DAYTONA, FL 32119

G-002

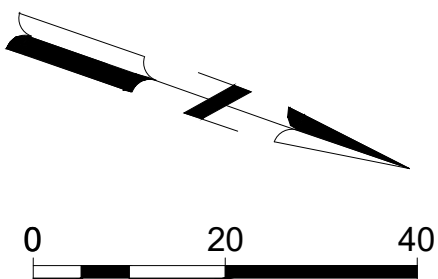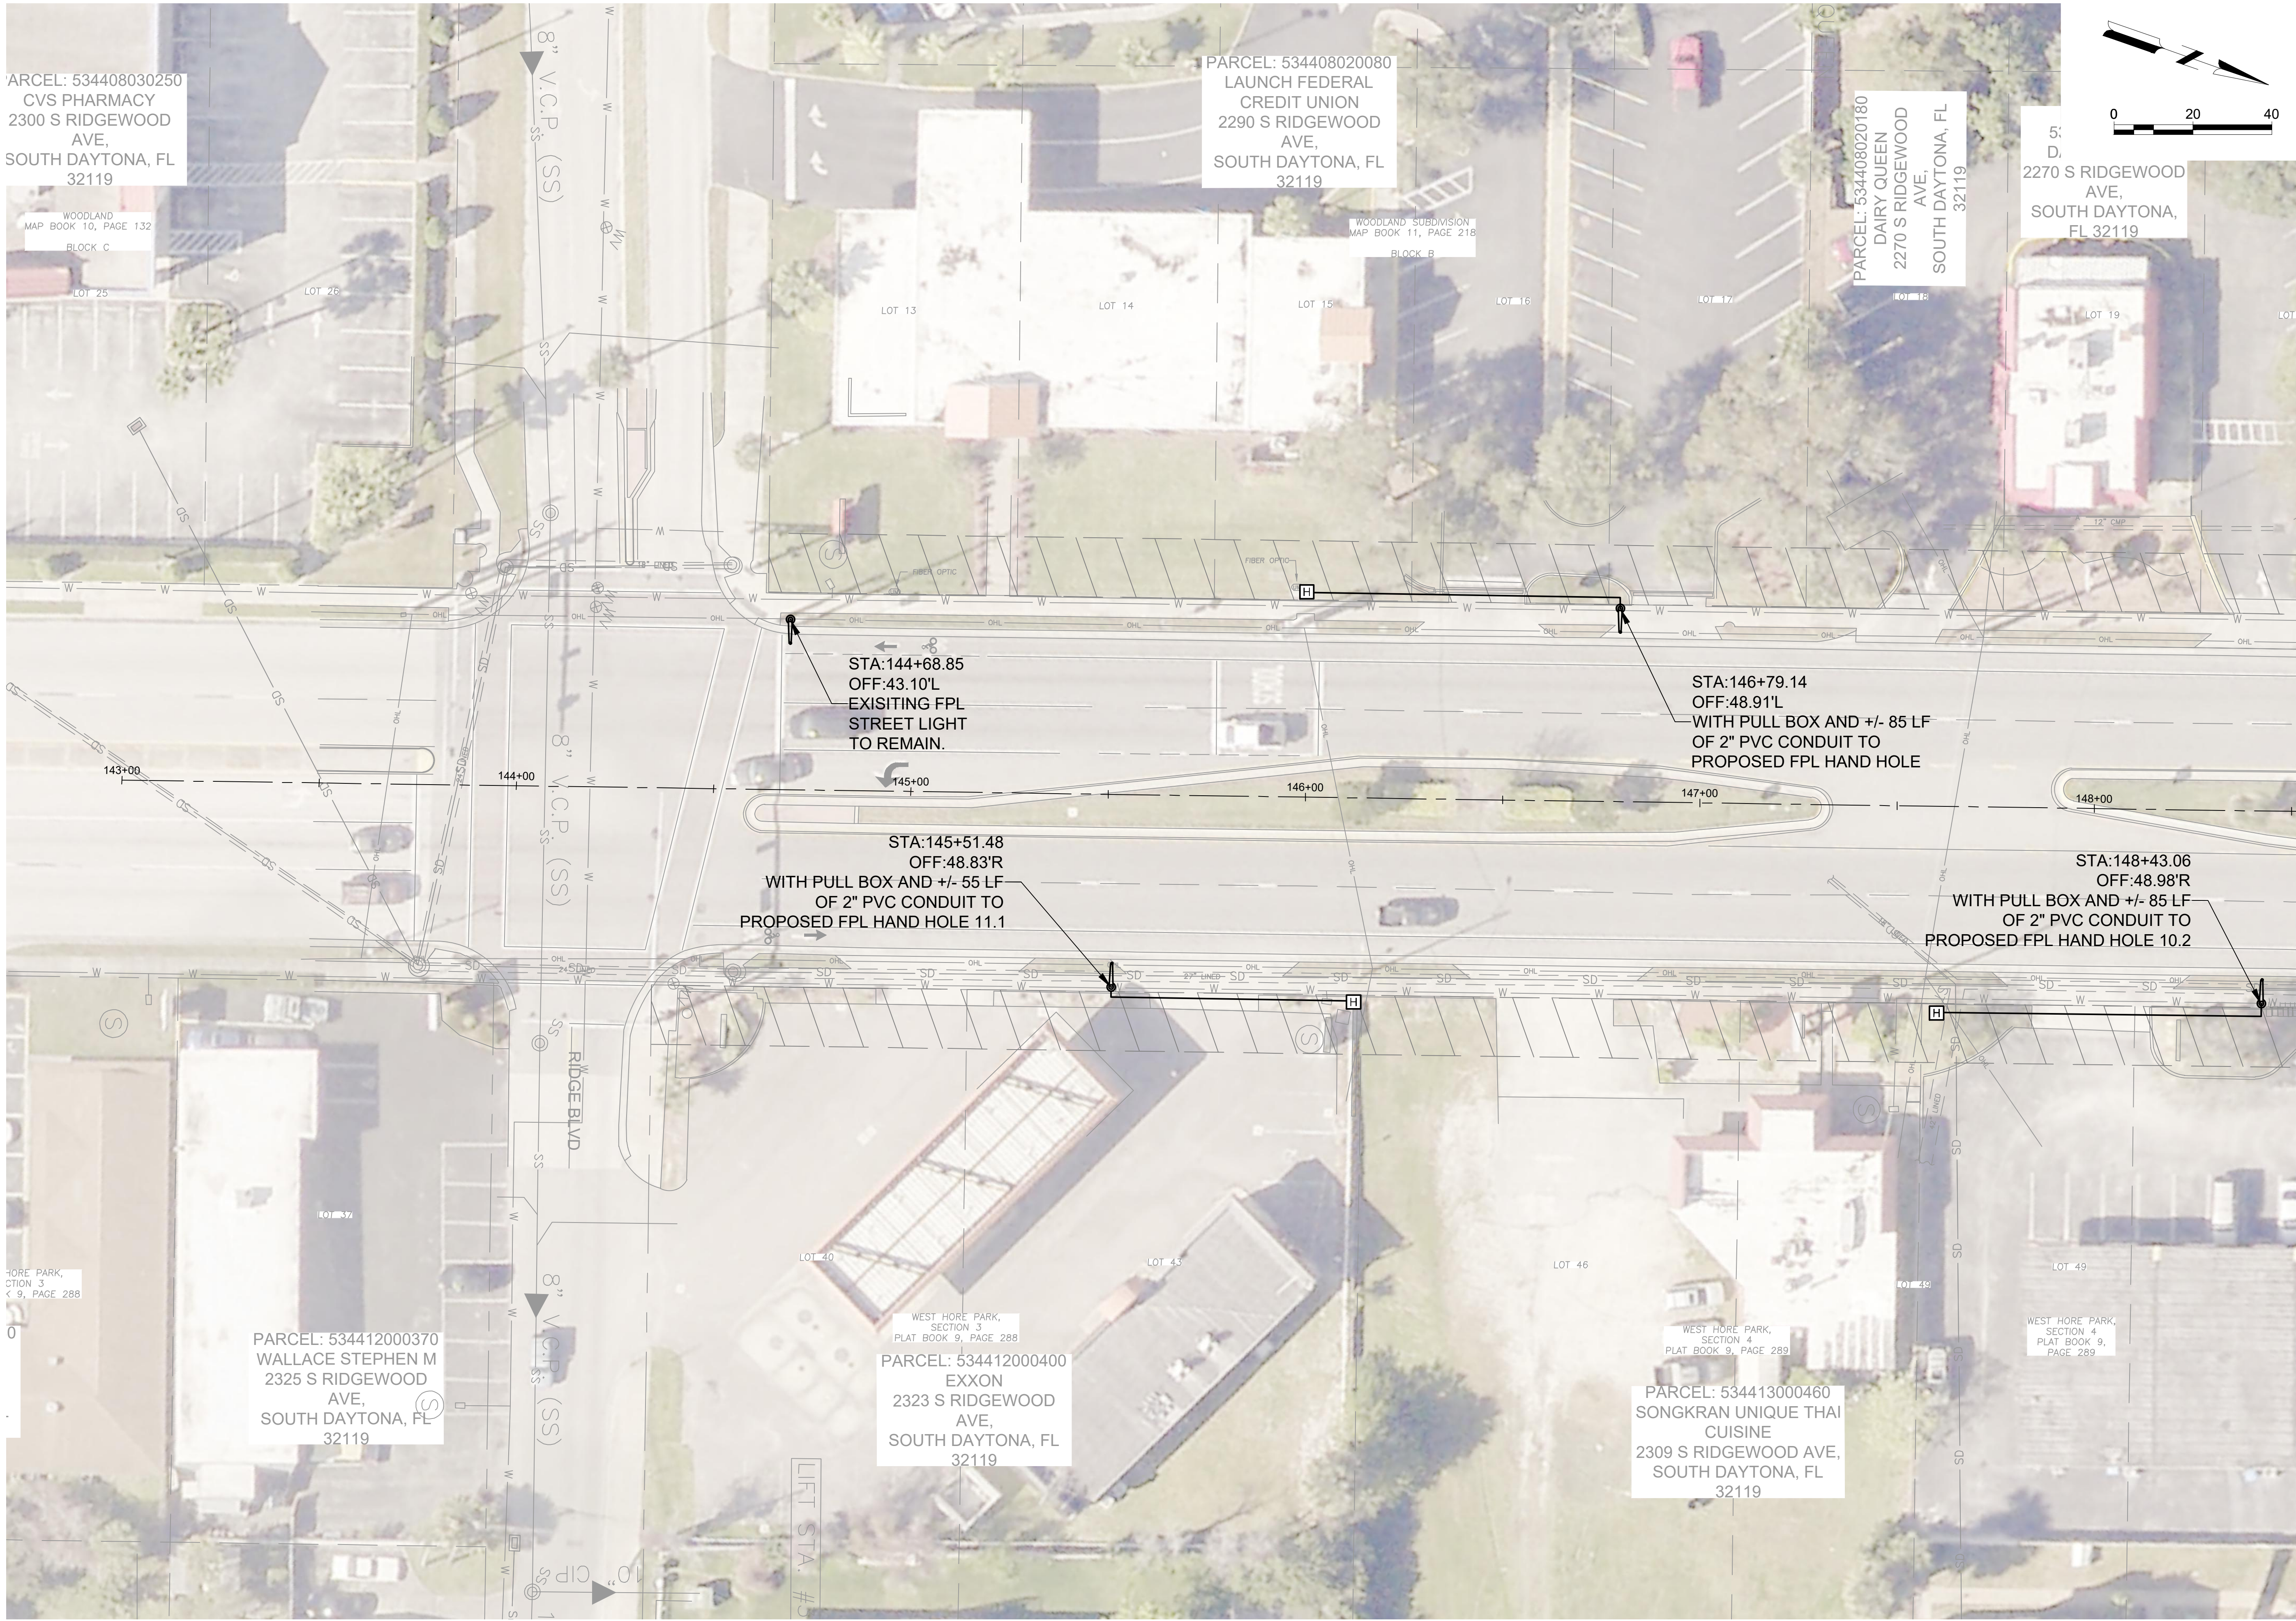

Mead & Hunt

Mead and Hunt, Inc.
4401 Eastport Parkway
Port Orange, FL 32127
phone: 386-761-6810
meadhunt.com
FL Cert. #26730



© Copyright 2025 Mead & Hunt, Inc.
This document, or any portion thereof, shall not be duplicated, disclosed, or used on any other project or extension of this project except by written agreement with Mead & Hunt, Inc. Mead & Hunt shall not be responsible for any unauthorized use of, or alteration to these documents.

**CITY OF SOUTH DAYTONA
US-1 UNDERGROUNDING
PH 2
S RIDGEWOOD AVE
SOUTH DAYTONA, FL 32119**

ISSUED

NOT FOR CONSTRUCTION

M&H NO.: 1000717-222018.01
DATE: JUNE 2025
DESIGNED BY: RJG
DRAWN BY: RJG
CHECKED BY: DAK
DO NOT SCALE DRAWINGS



SHEET CONTENTS
LIGHT POLES

SHEET NO.

C-100

\\CORP.MEADHUNT.COM\SHARED\FOLDERS\ENTR1000717\222018.01\TECH\CAD\DRAWINGS\LIGHT POLES.DWG
6/19/2025 9:20:54 AM

MATCH LINE SEE SHEET C-100

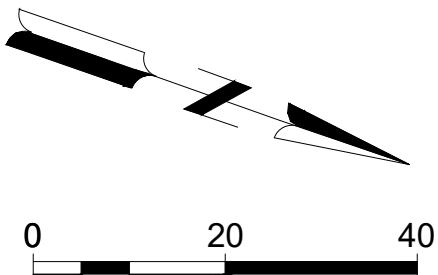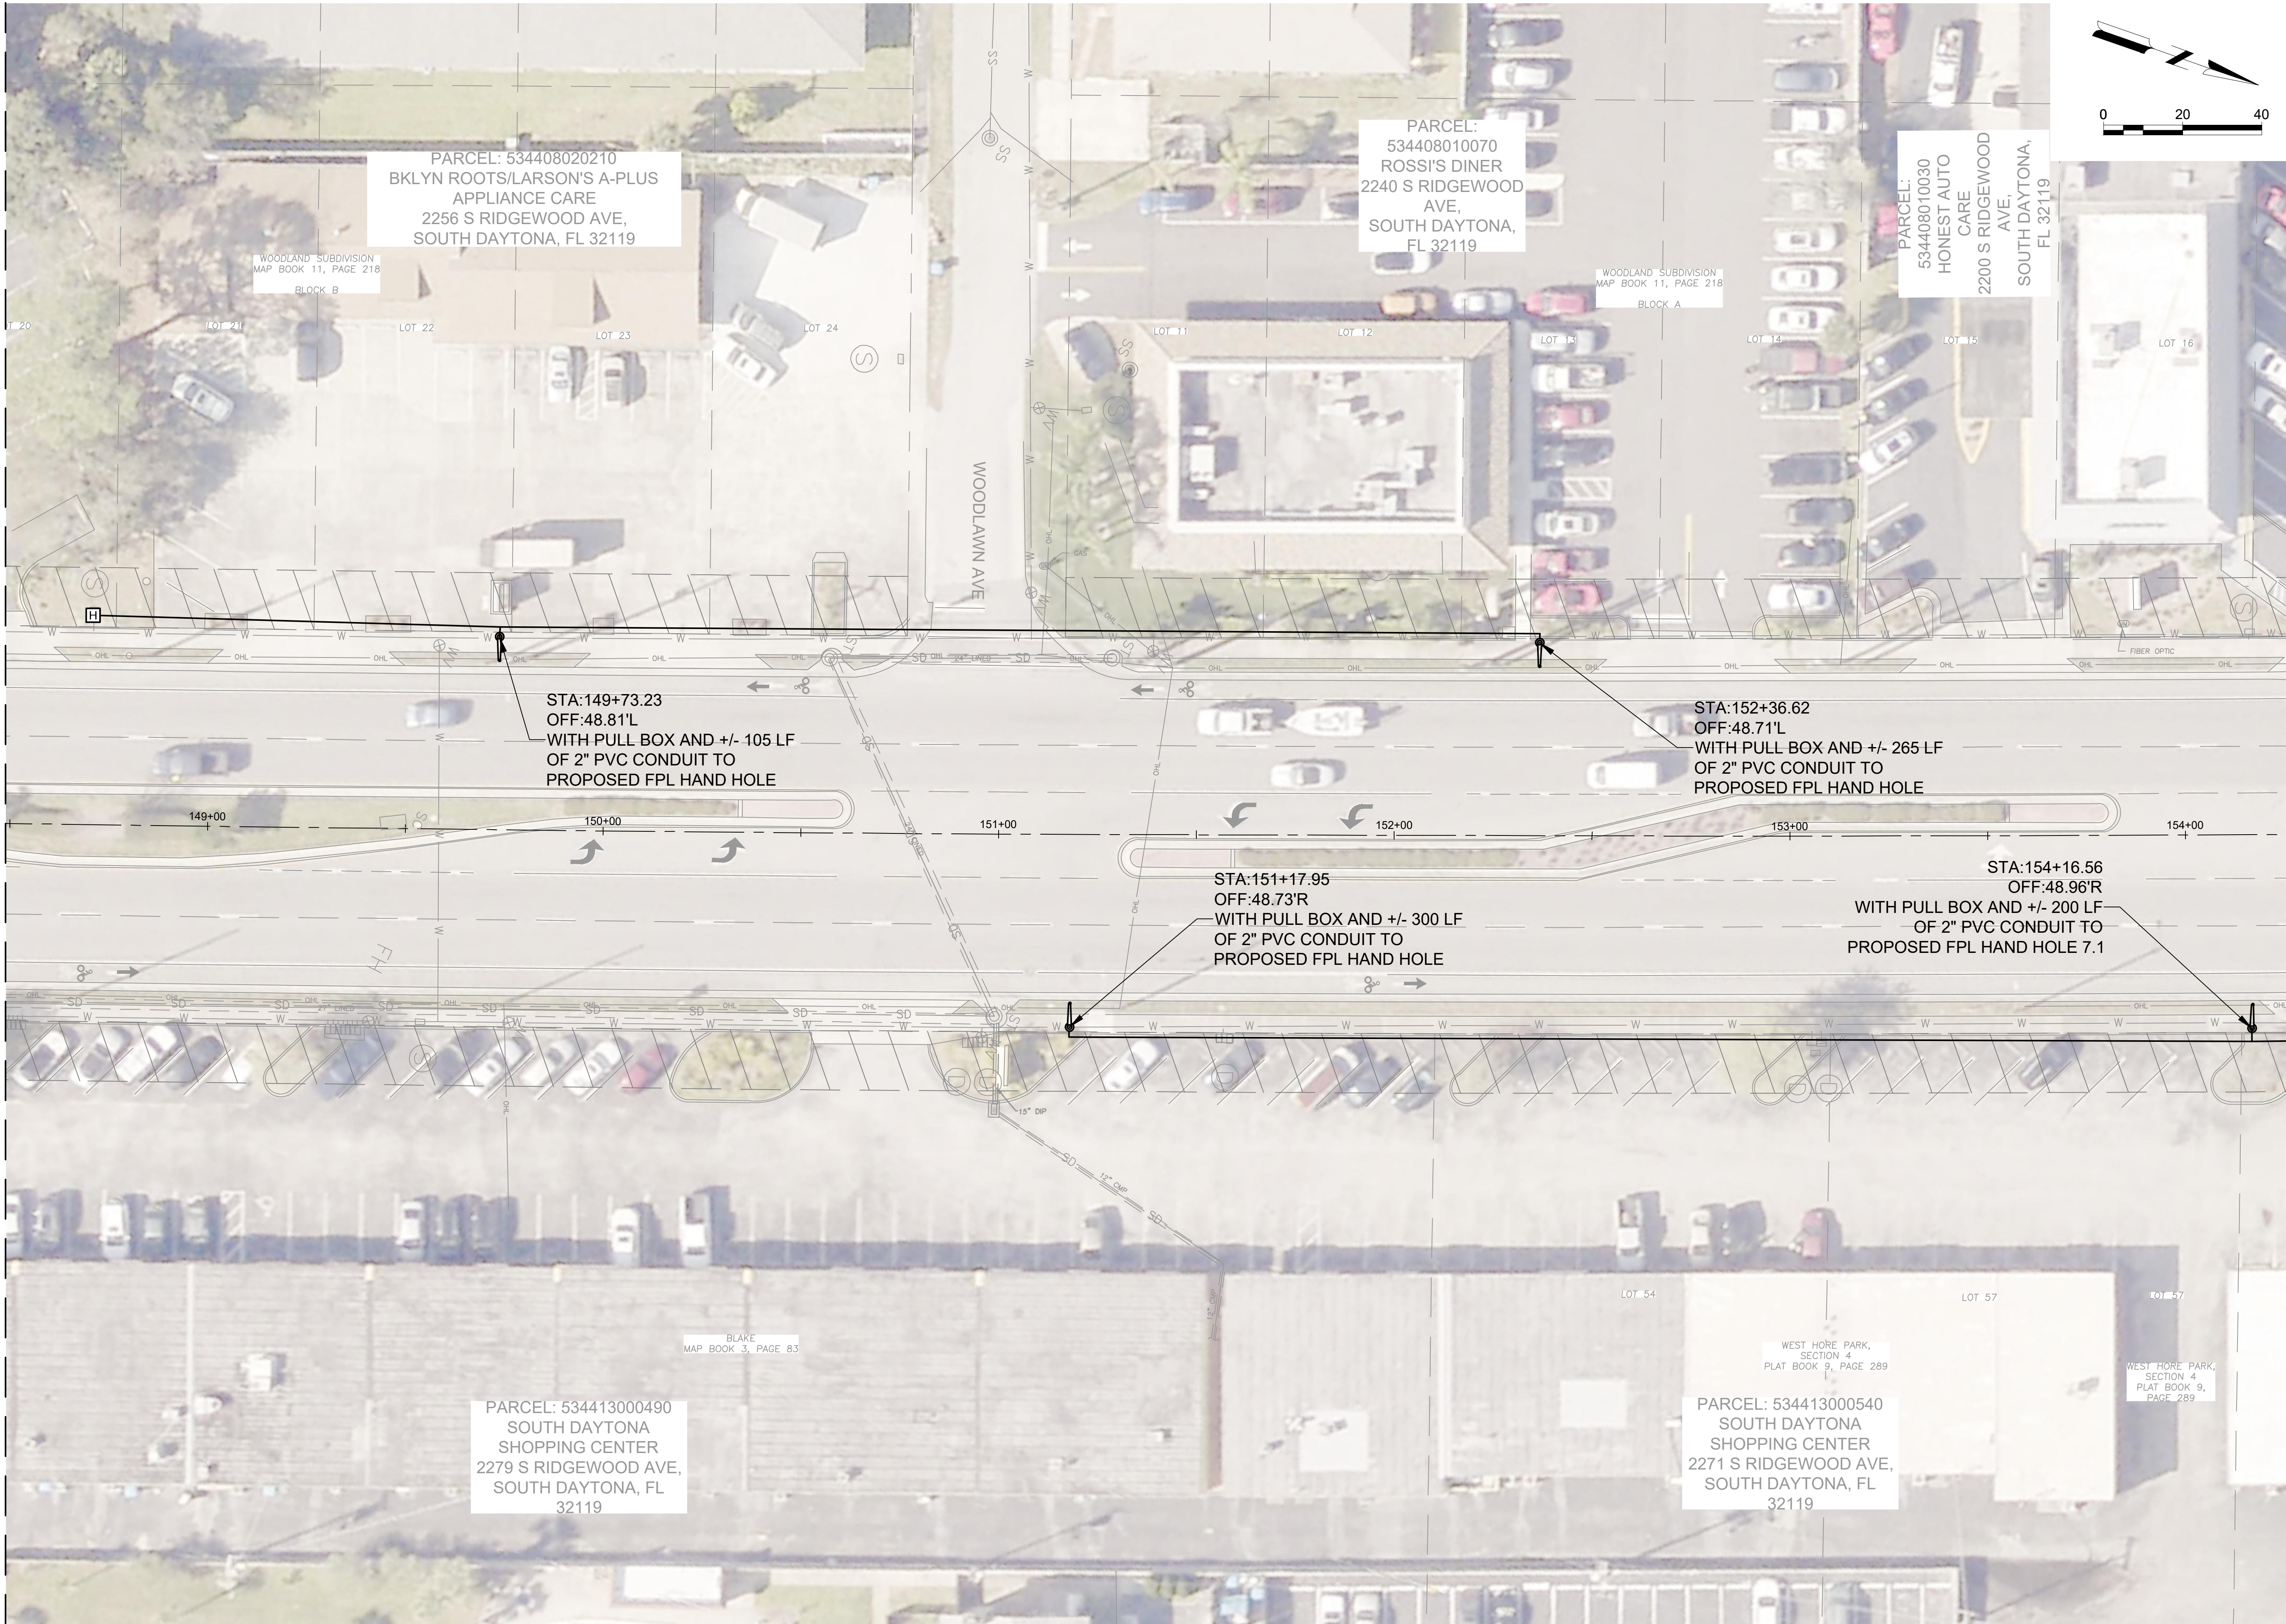

Mead & Hunt
Mead and Hunt, Inc.
4401 Eastport Parkway
Port Orange, FL 32127
phone: 386-761-6810
meadhunt.com
FL Cert. #26730

SOUTH DAYTONA
SMALL CITY. BIG POSSIBILITIES.

© Copyright 2025 Mead & Hunt, Inc.
This document, or any portion thereof, shall not be duplicated, disclosed, or used on any other project or extension of this project except by written agreement with Mead & Hunt, Inc. Mead & Hunt shall not be responsible for any unauthorized use of, or alteration to these documents.

CITY OF SOUTH DAYTONA
US-1 UNDERGROUNDING
PH 2
S RIDGEWOOD AVE
SOUTH DAYTONA, FL 32119

ISSUED

NOT FOR CONSTRUCTION

M&H NO.: 1000717-222018.01
DATE: JUNE 2025
DESIGNED BY: RJG
DRAWN BY: RJG
CHECKED BY: DAK
DO NOT SCALE DRAWINGS


SHEET CONTENTS
LIGHT POLES

SHEET NO.

C-101

\\CORP.MEADHUNT.COM\SHARED\FOLDERS\ENTR1000717\222018.01\TECH\CAD\DRAWINGS\LIGHT POLES.DWG
6/19/2025 9:20:59 AM

MATCH LINE SEE SHEET C-101

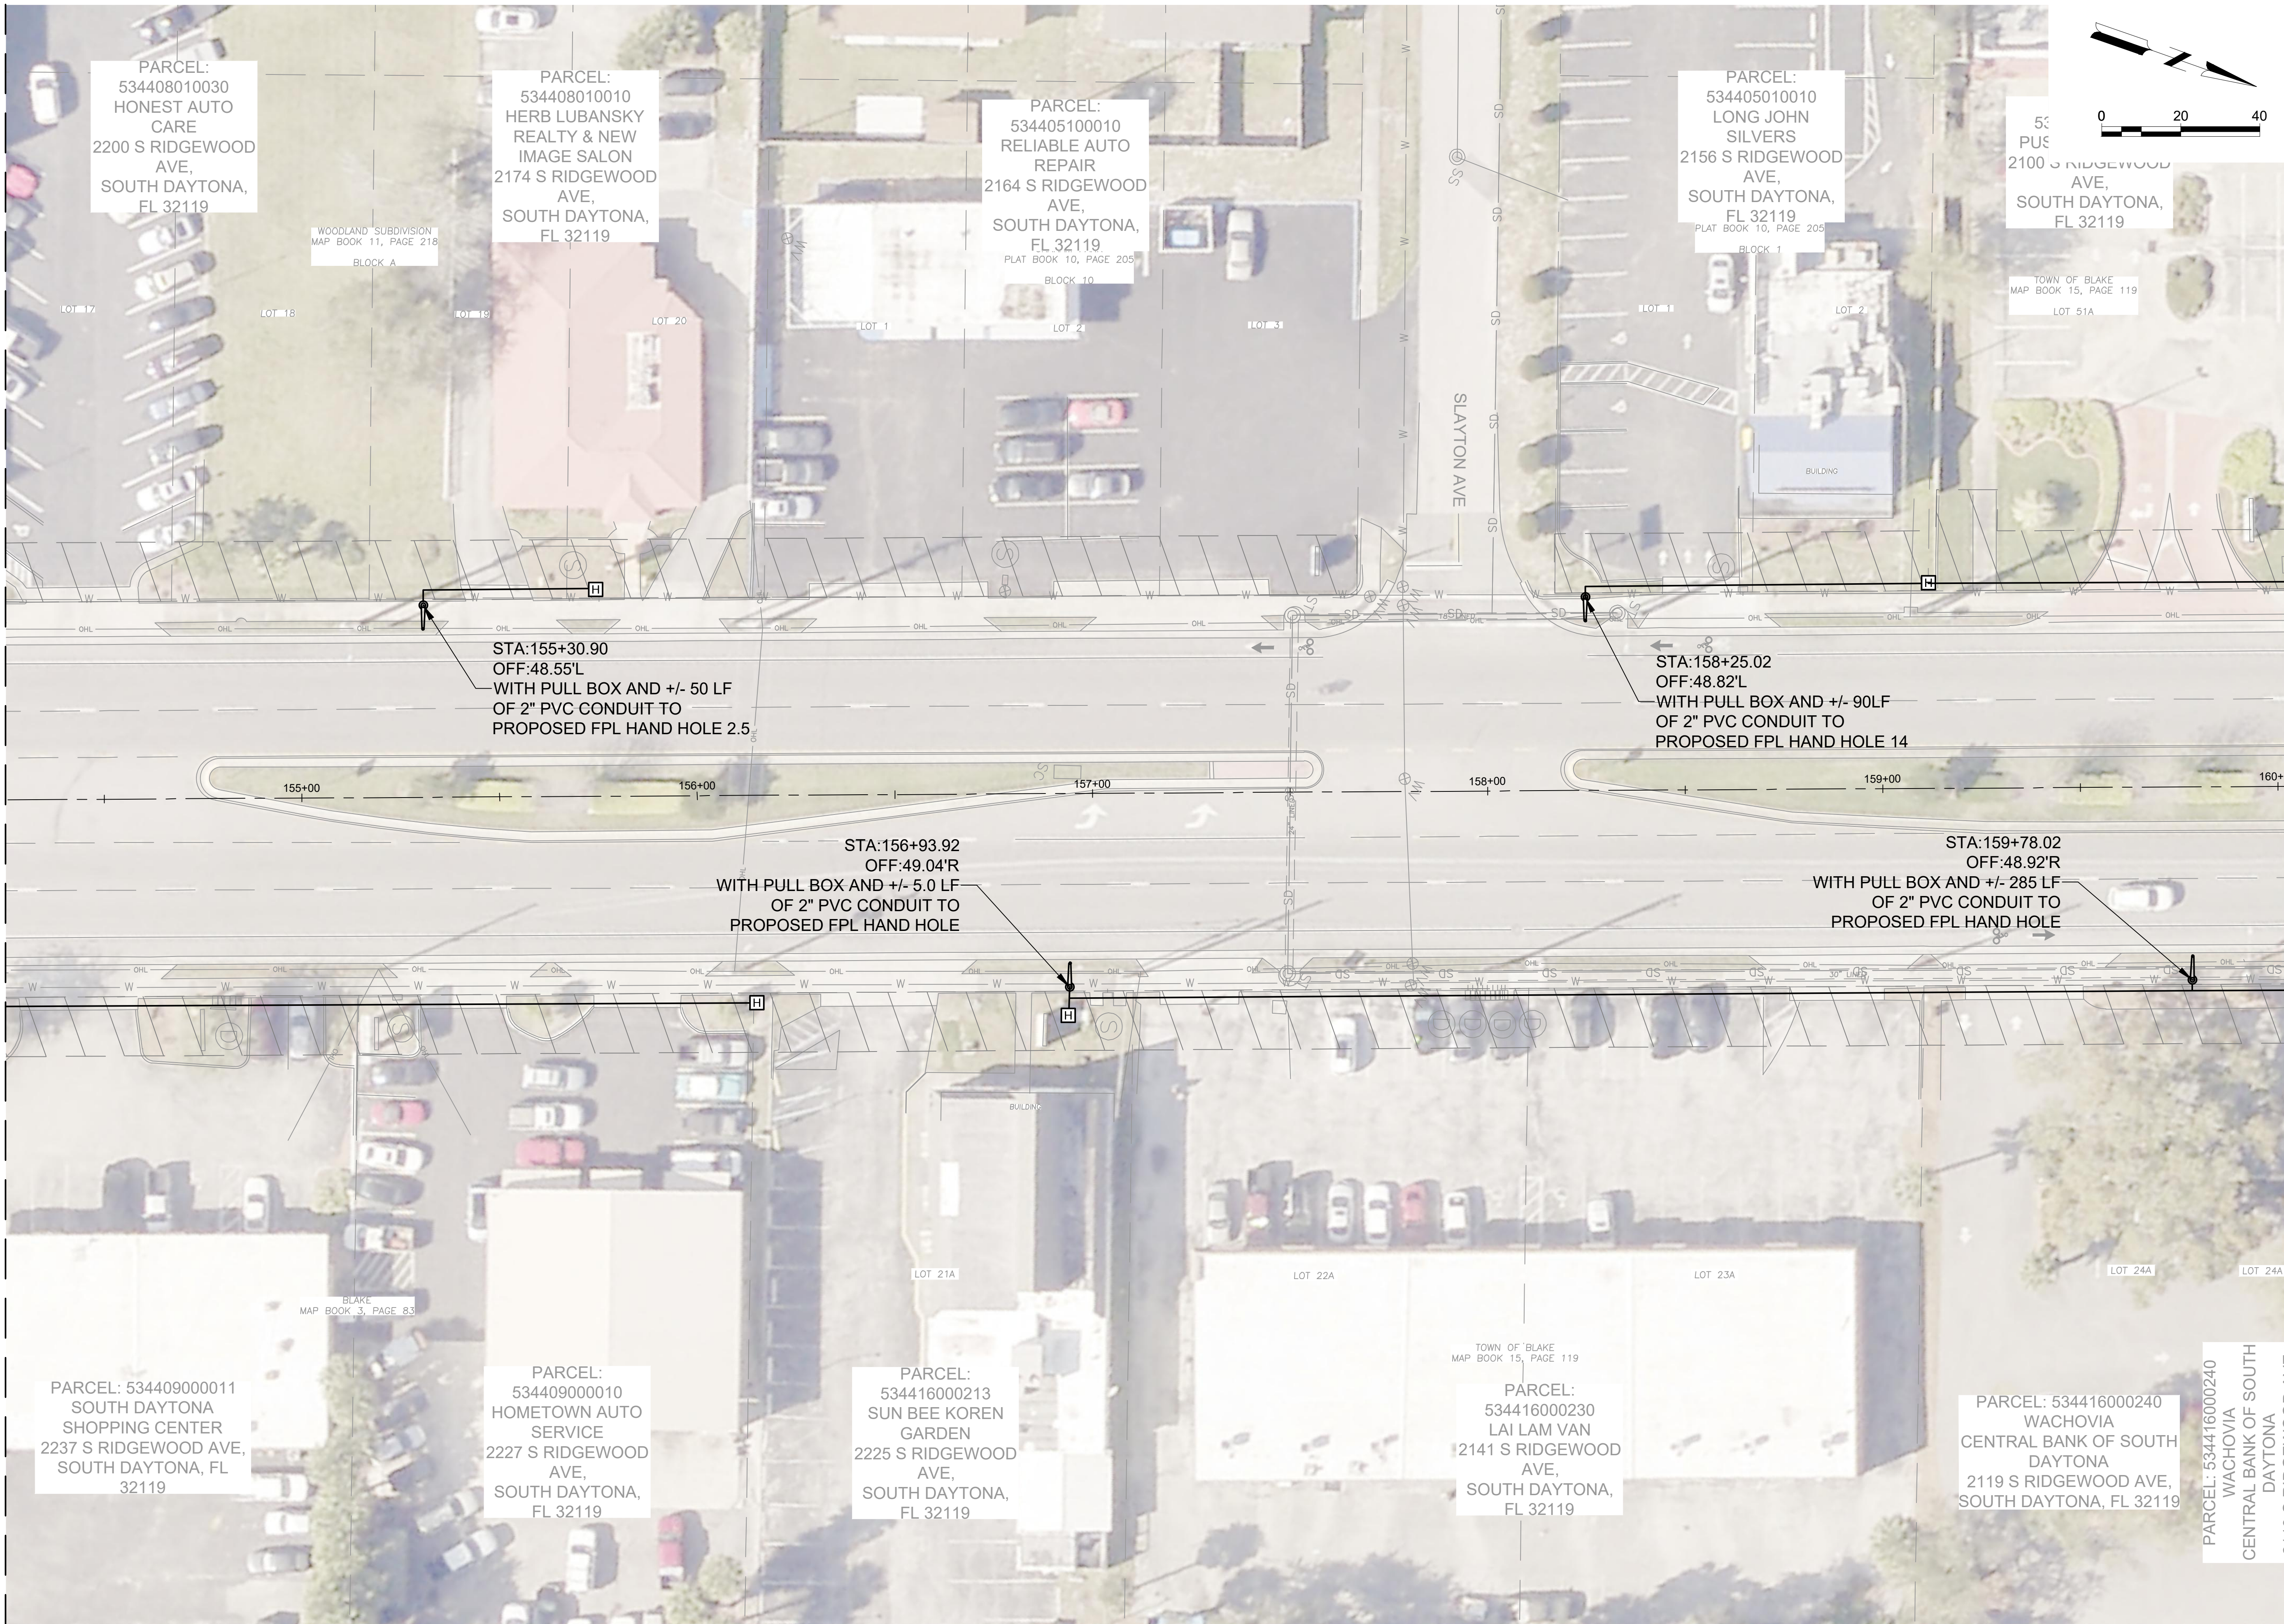

Mead & Hunt
Mead and Hunt, Inc.
4401 Eastport Parkway
Port Orange, FL 32127
phone: 386-761-6810
meadhunt.com
FL Cert. #26730

SOUTH DAYTONA
SMALL CITY. BIG POSSIBILITIES.

© Copyright 2025 Mead & Hunt, Inc.
This document, or any portion thereof, shall not be duplicated, disclosed, or used on any other project or extension of this project except by written agreement with Mead & Hunt, Inc. Mead & Hunt shall not be responsible for any unauthorized use of, or alteration to these documents.

CITY OF SOUTH DAYTONA
US-1 UNDERGROUNDING
PH 2
S RIDGEWOOD AVE
SOUTH DAYTONA, FL 32119

ISSUED

NOT FOR CONSTRUCTION

M&H NO.: 1000717-222018.01
DATE: JUNE 2025
DESIGNED BY: RJG
DRAWN BY: RJG
CHECKED BY: DAK
DO NOT SCALE DRAWINGS


SHEET CONTENTS
LIGHT POLES

SHEET NO.

C-102

\\CORP.MEADHUNT.COM\SHARED\FOLDERS\ENTR1000717\222018.01\TECH\CAD\DRAWINGS\LIGHT POLES.DWG
6/19/2025 9:21:04 AM

MATCH LINE SEE SHEET C-102

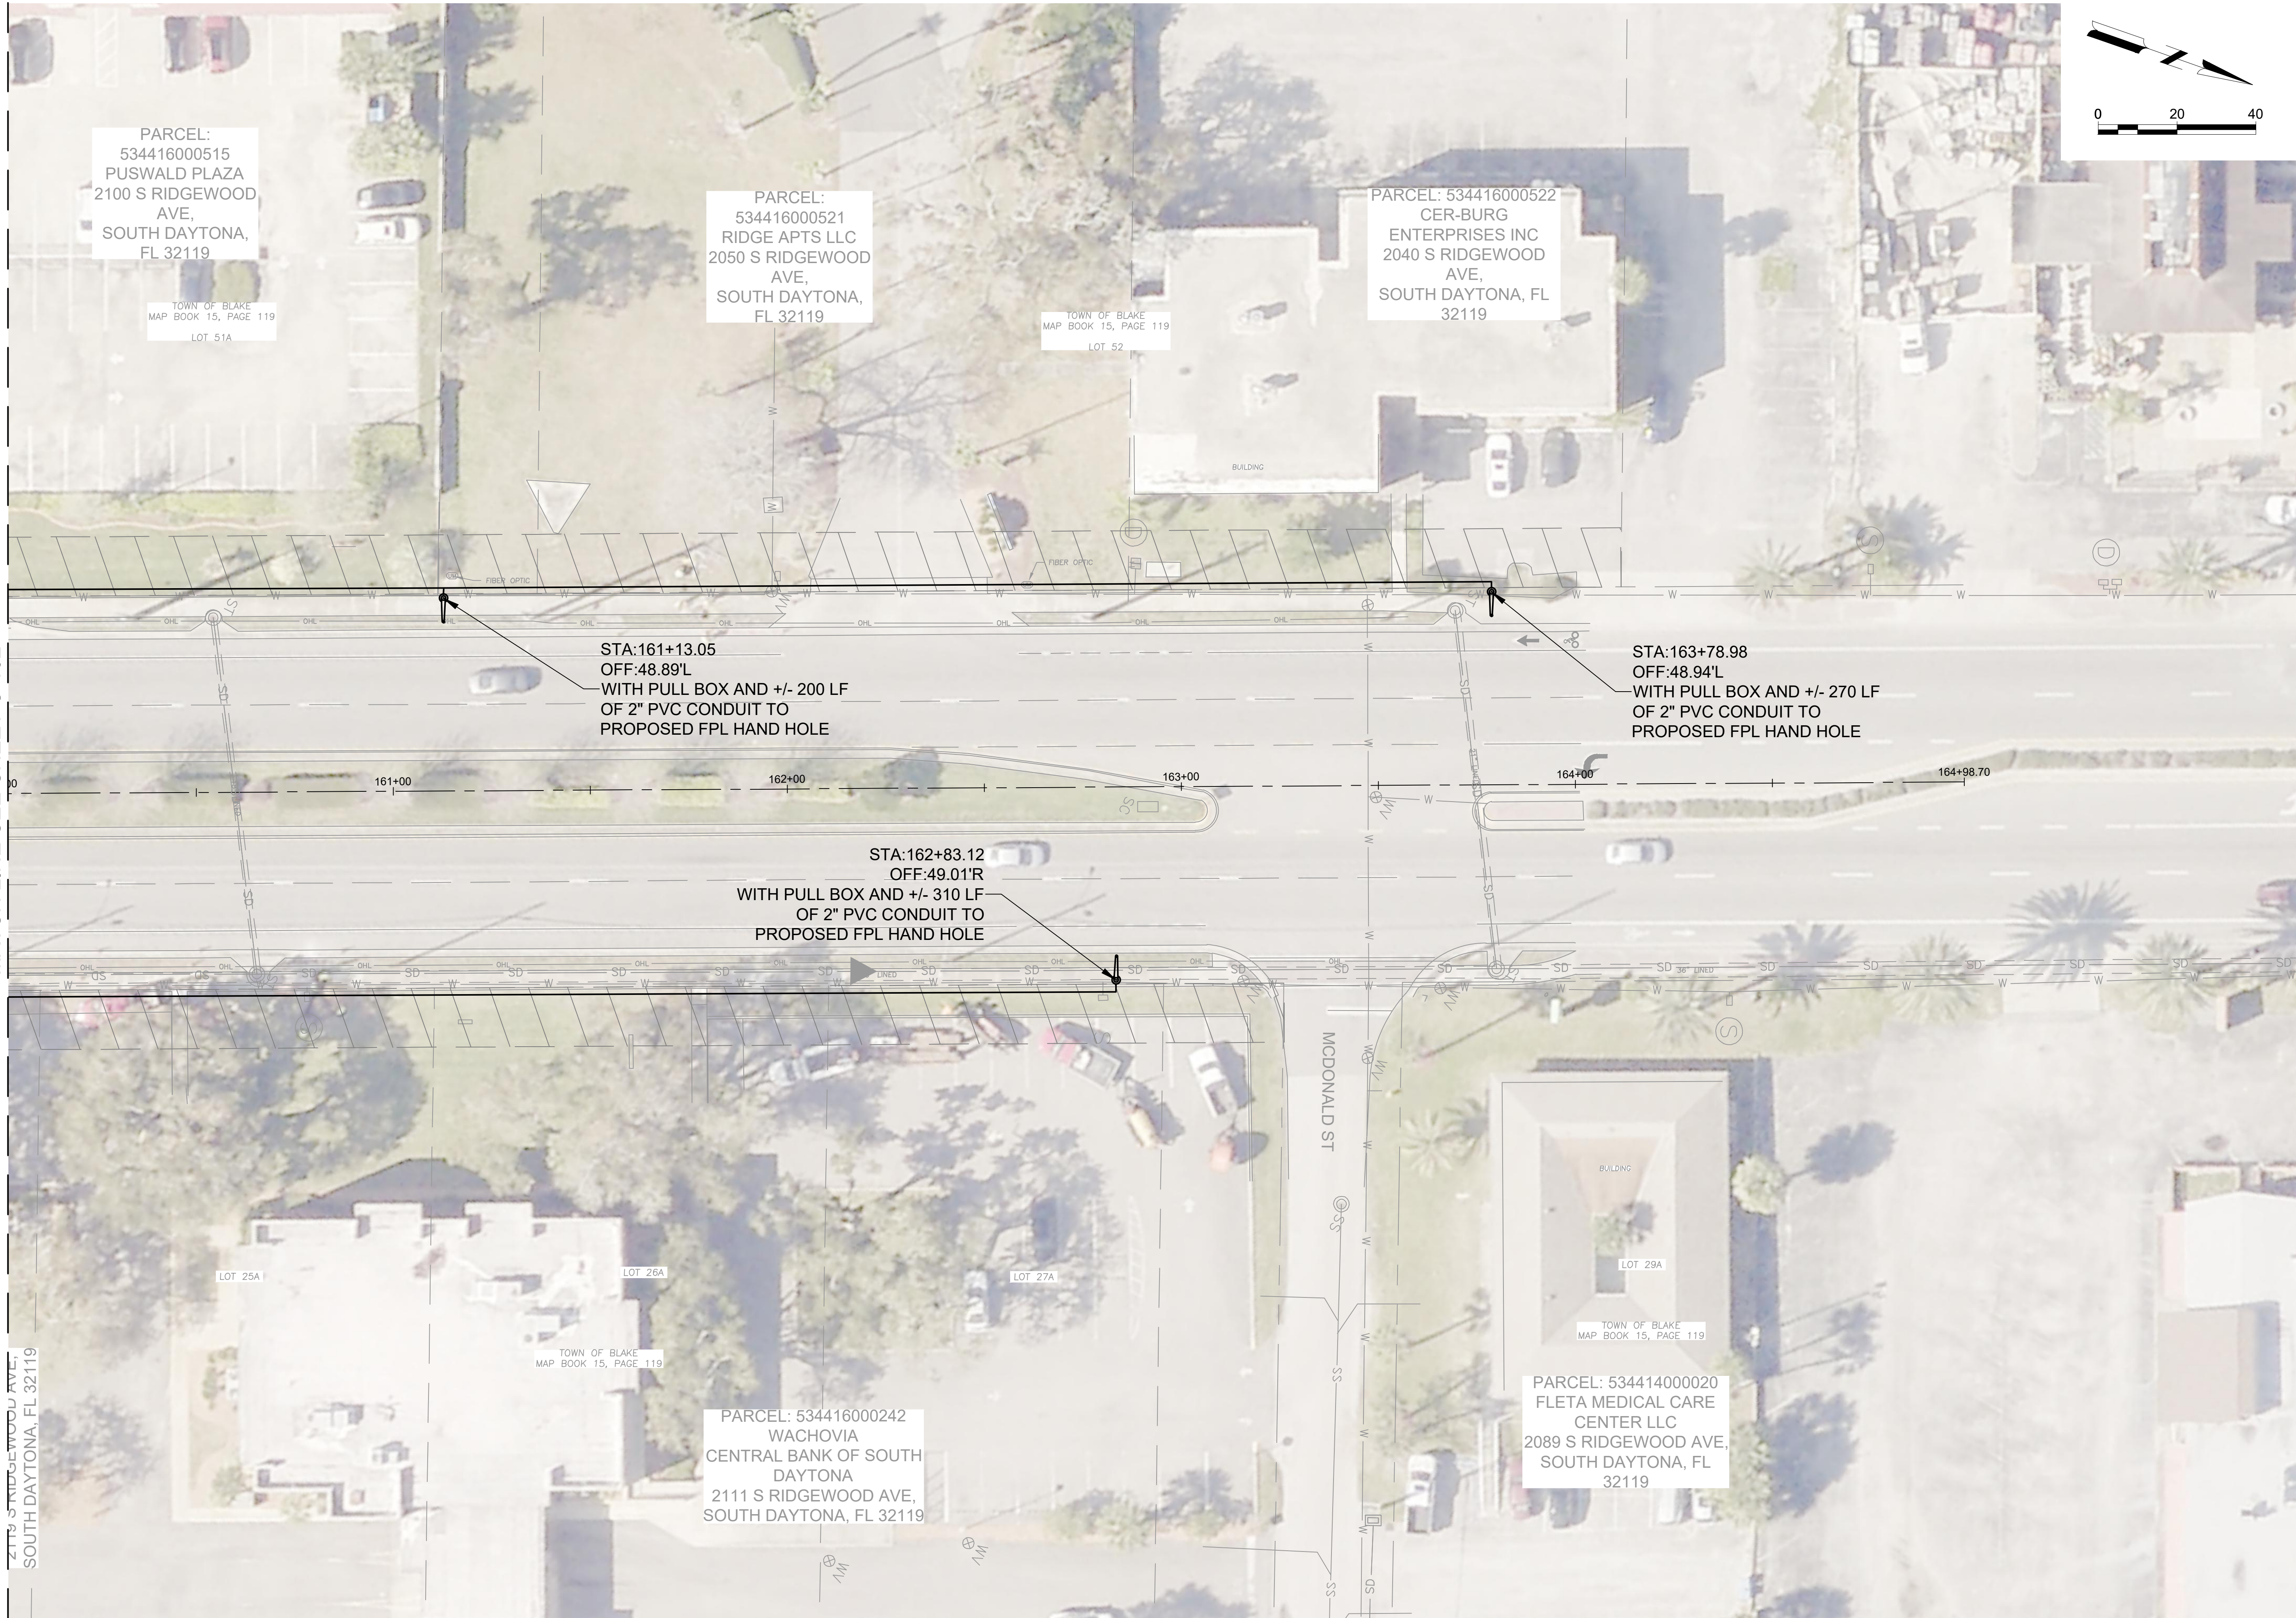

Mead & Hunt

Mead and Hunt, Inc.
4401 Eastport Parkway
Port Orange, FL 32127
phone: 386-761-6810
meadhunt.com
FL Cert. #26730



© Copyright 2025 Mead & Hunt, Inc.
This document, or any portion thereof, shall not be duplicated, disclosed, or used on any other project or extension of this project except by written agreement with Mead & Hunt, Inc. Mead & Hunt shall not be responsible for any unauthorized use of, or alteration to these documents.

CITY OF SOUTH DAYTONA
US-1 UNDERGROUNDING
PH 2

S RIDGEWOOD AVE
SOUTH DAYTONA, FL 32119

ISSUED

NOT FOR CONSTRUCTION


M&H NO.: 1000717-222018.01
DATE: JUNE 2025
DESIGNED BY: RJG
DRAWN BY: RJG
CHECKED BY: DAK
DO NOT SCALE DRAWINGS

SHEET CONTENTS
LIGHT POLES


SHEET NO.

C-103

TYPICAL EXISTING CROSS SECTION

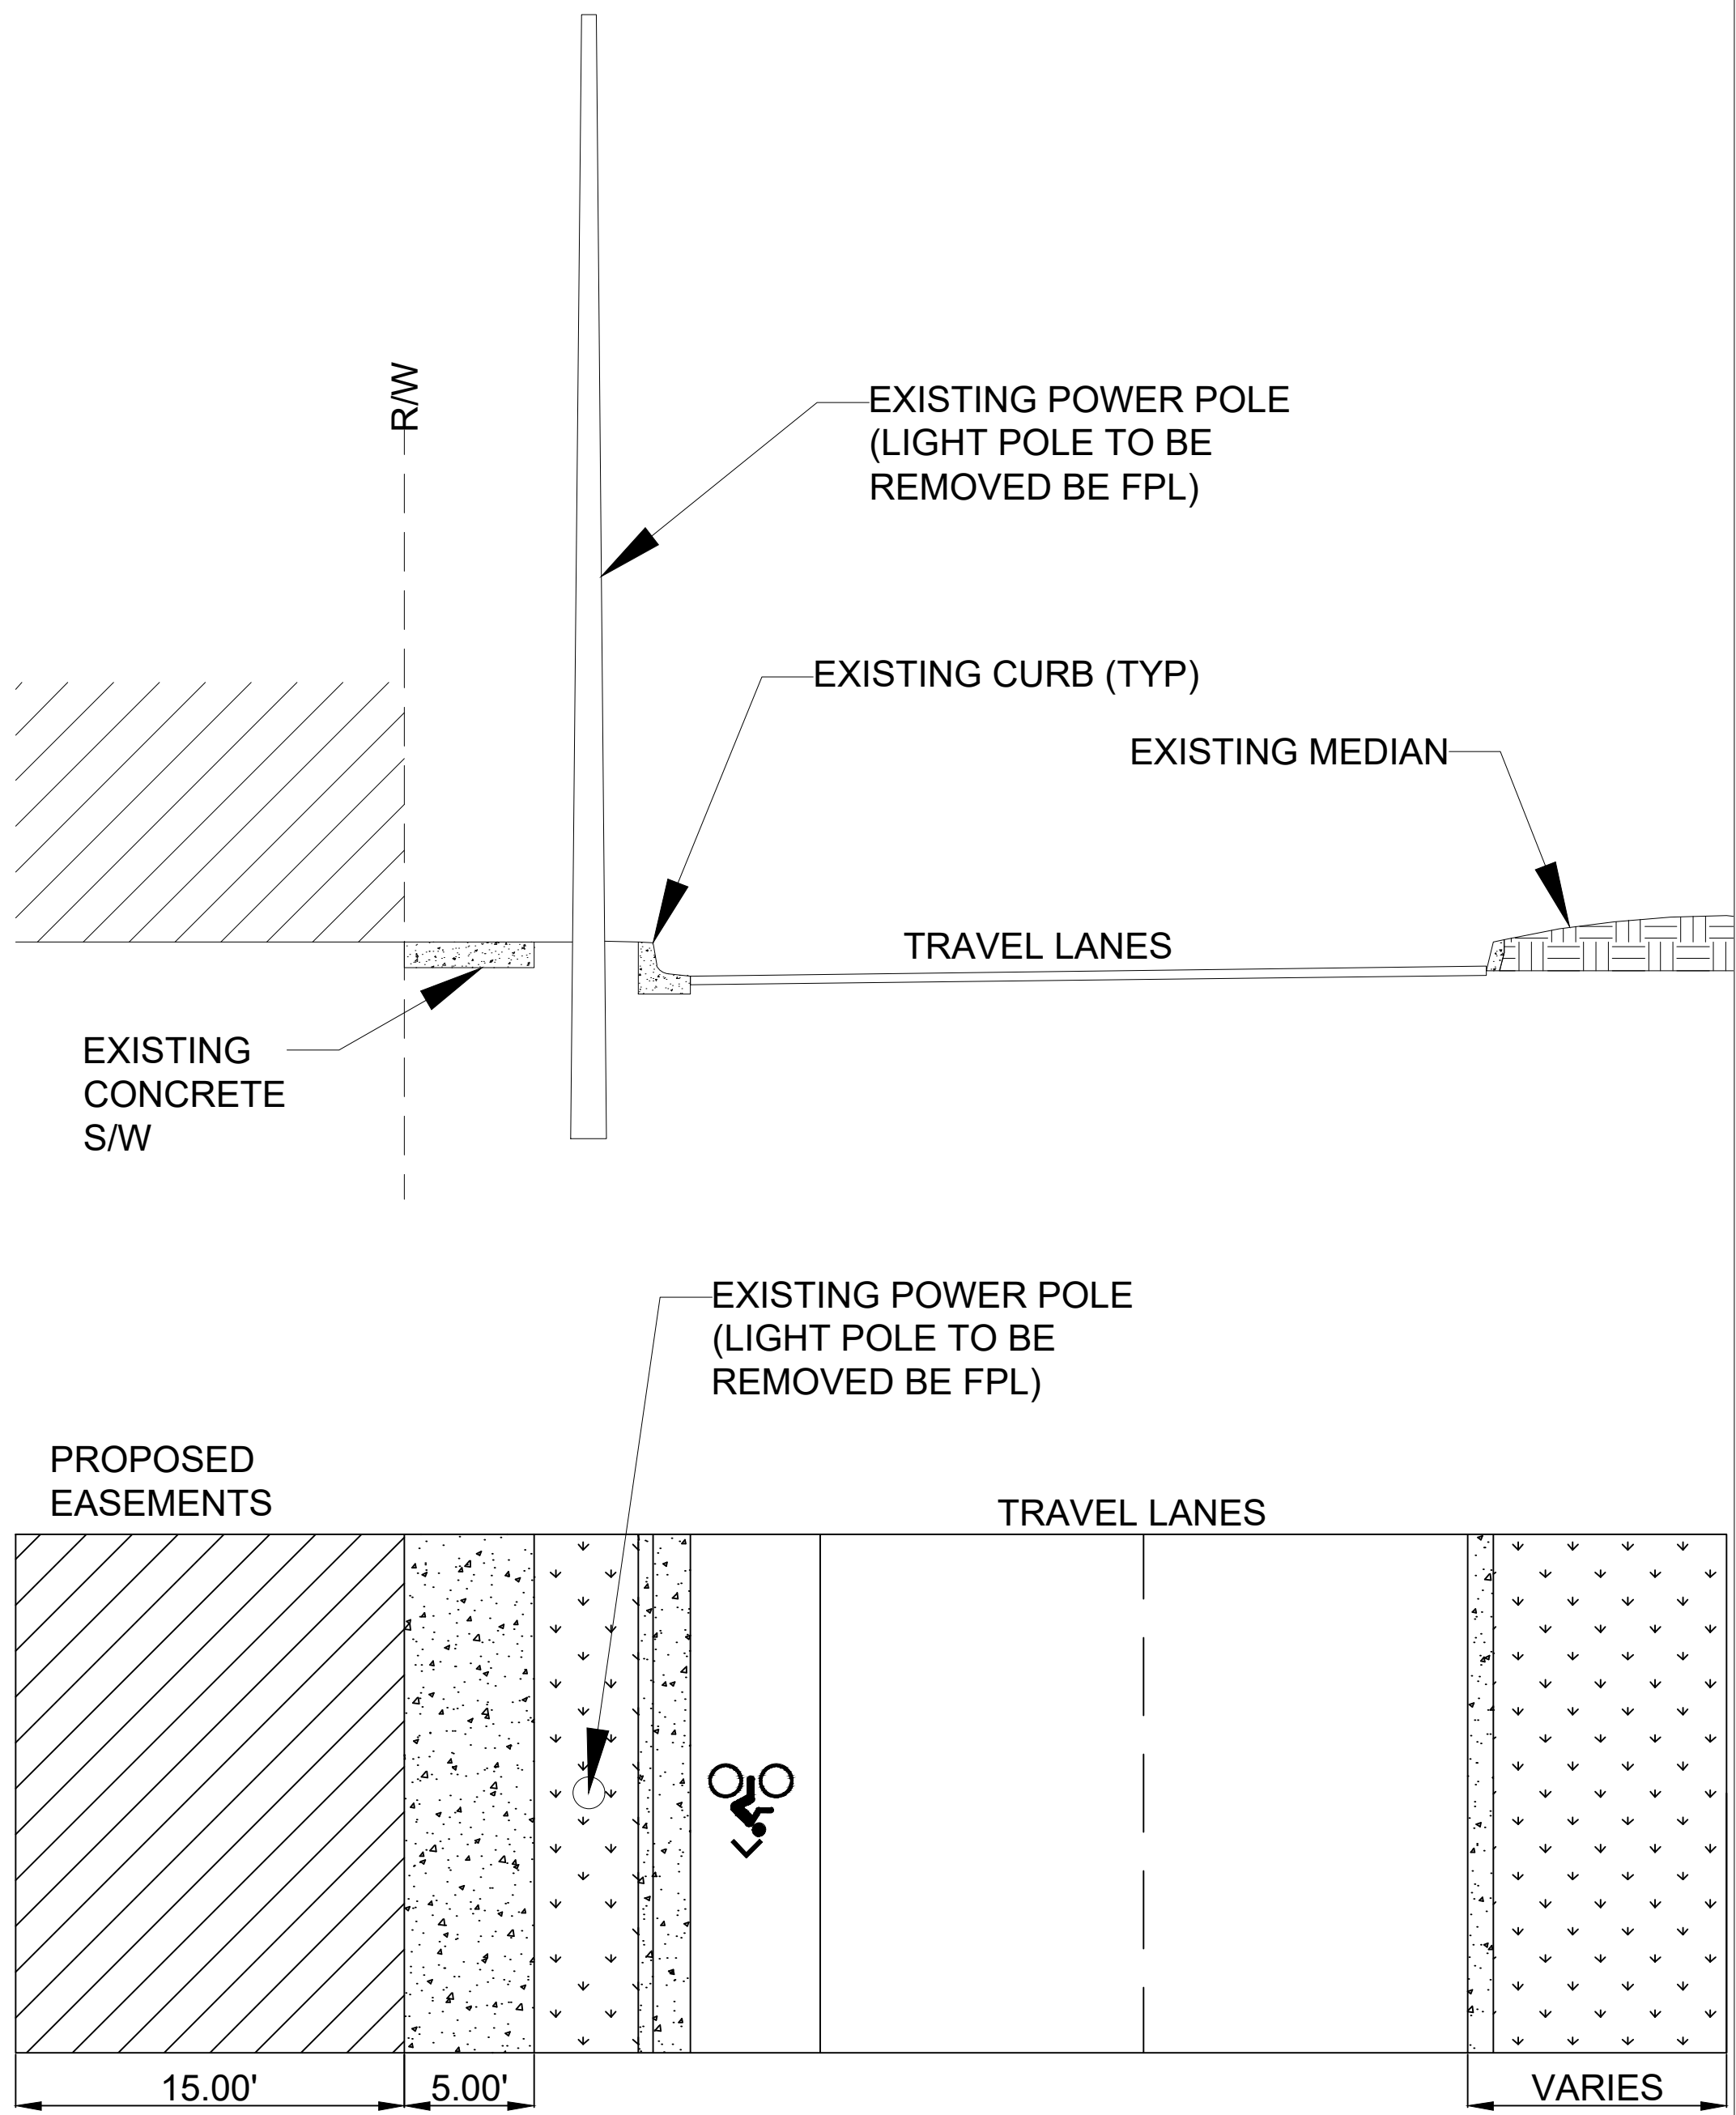

TYPICAL PROPOSED CROSS SECTION

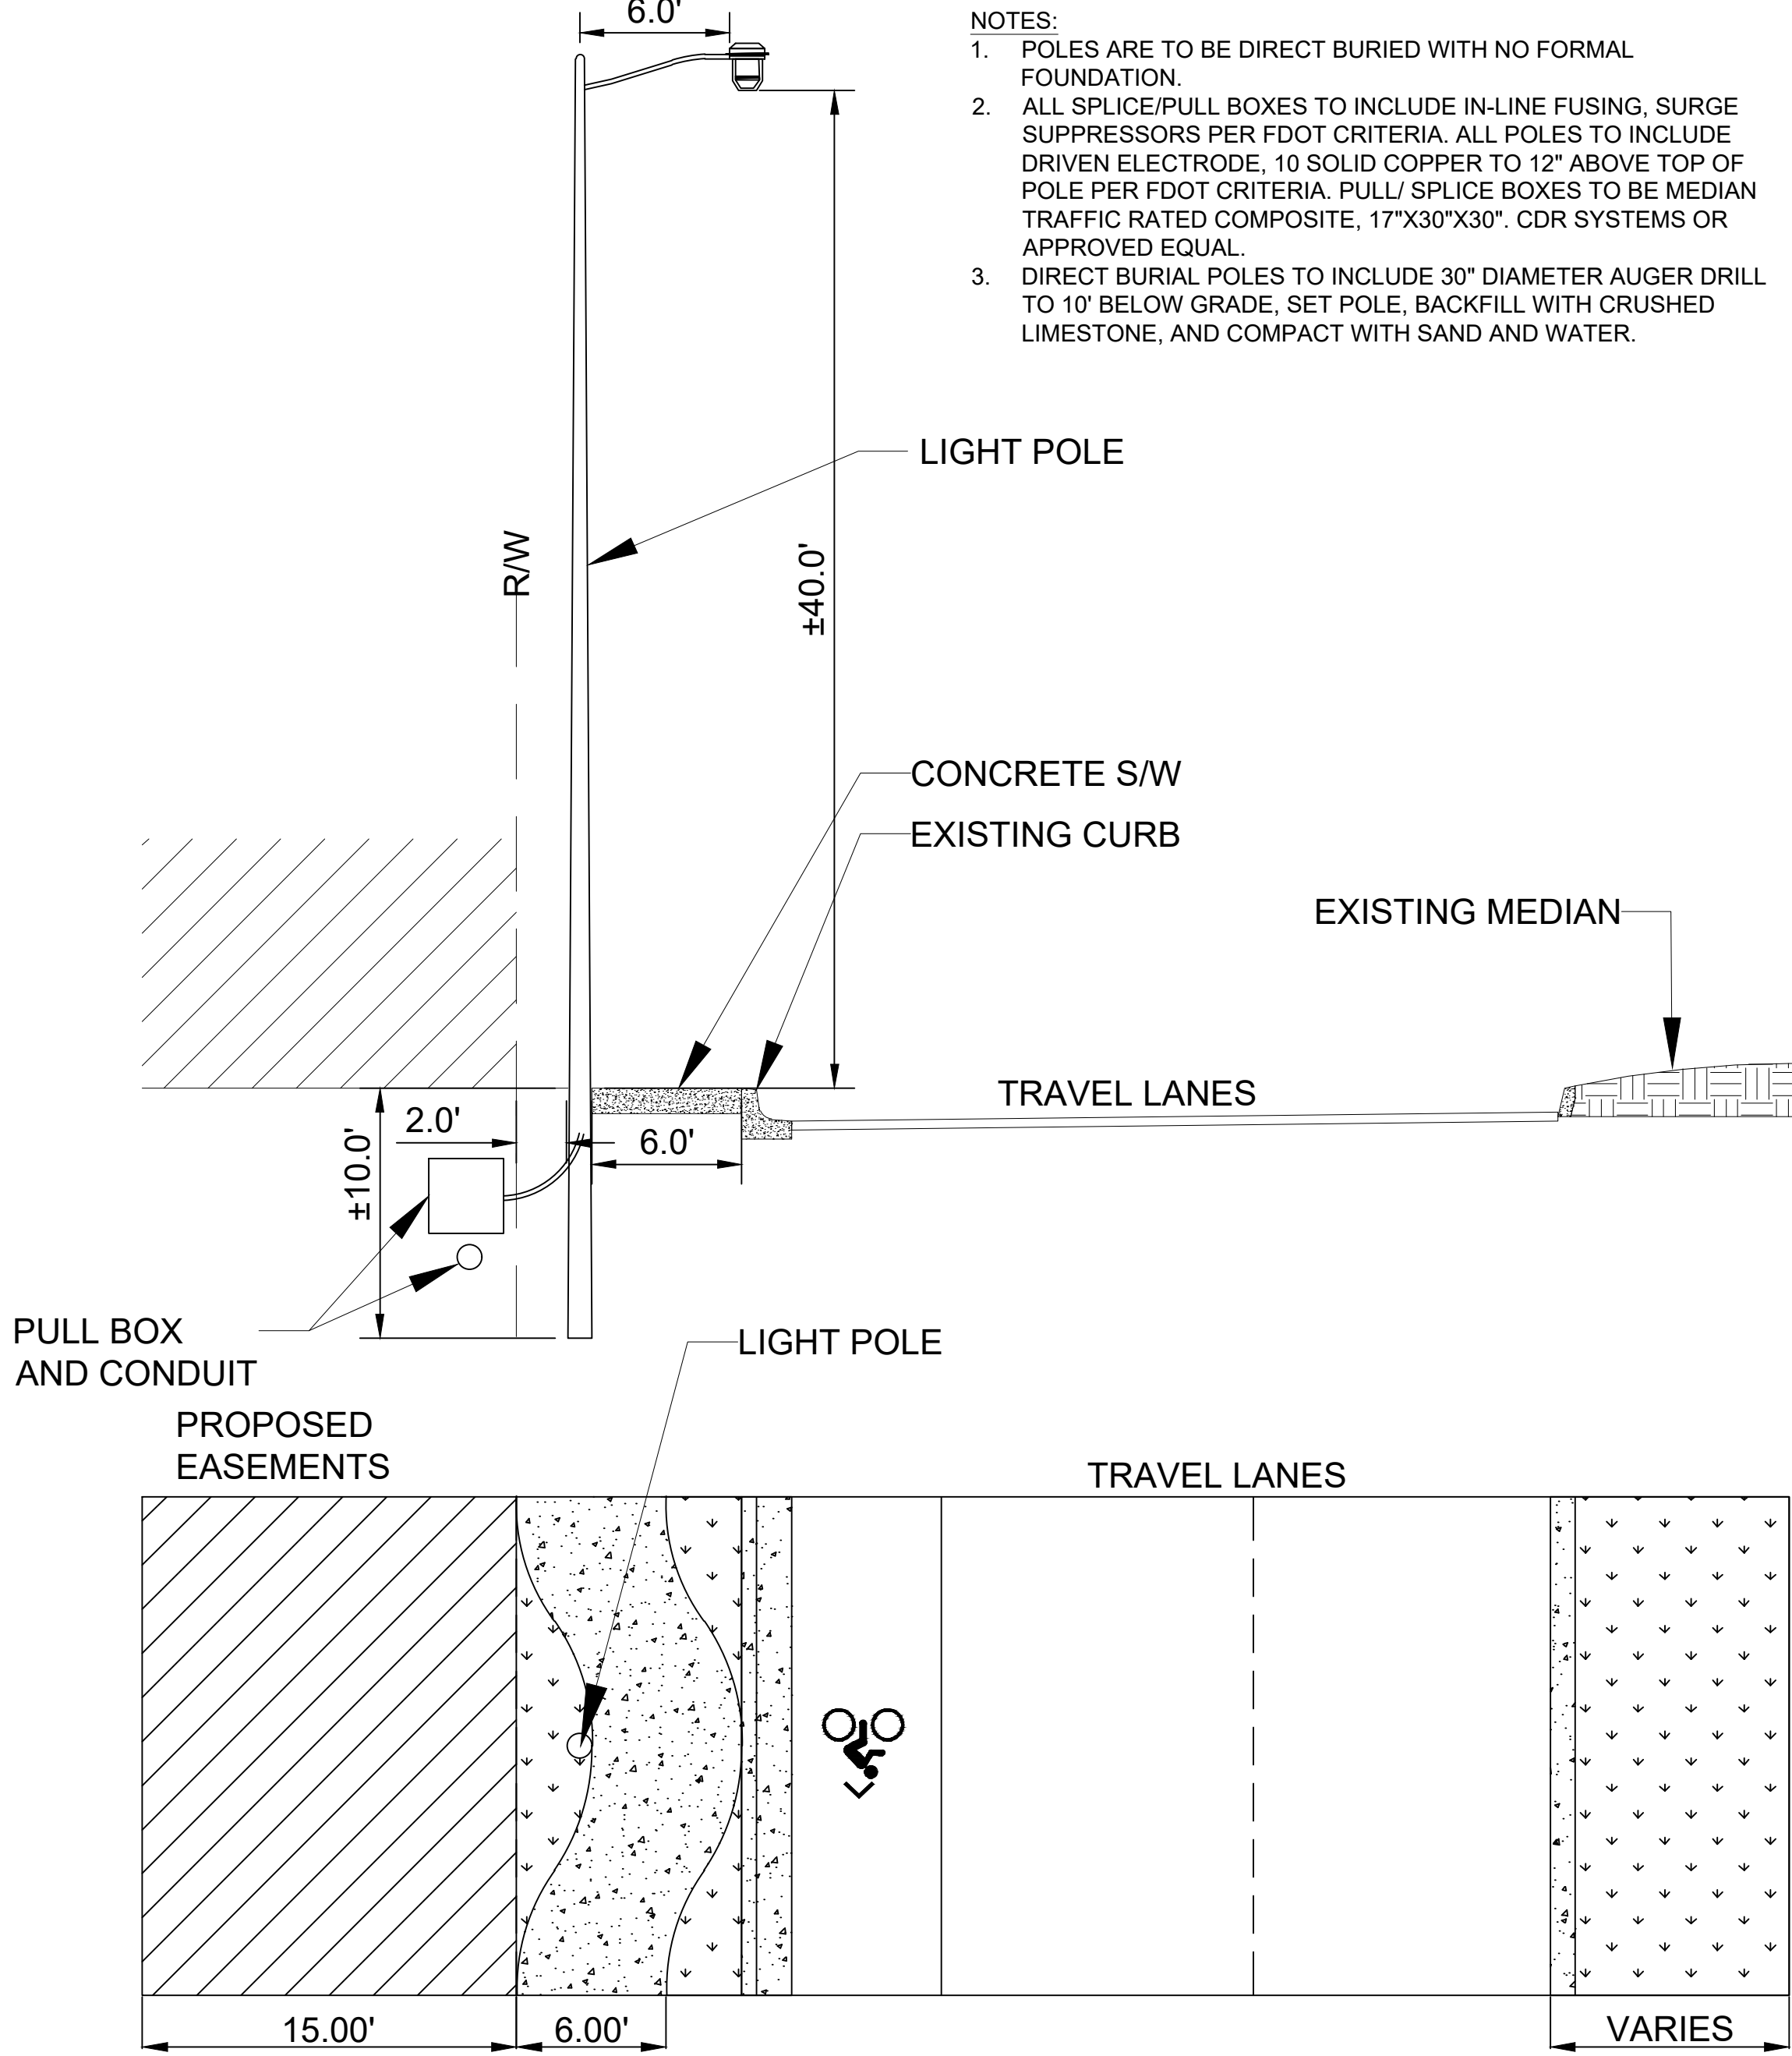

Mead and Hunt, Inc.
4401 Eastport Parkway
Port Orange, FL 32127
phone: 386-761-6810
meadhunt.com
FL Cert. #26730



© Copyright 2025 Mead & Hunt, Inc.
This document, or any portion thereof, shall not be duplicated, disclosed, or used on any other project or extension of this project except by written agreement with Mead & Hunt, Inc. Mead & Hunt shall not be responsible for any unauthorized use of, or alteration to these documents.

CITY OF SOUTH DAYTONA
US-1 UNDERGROUNDING
PH 2
S RIDGEWOOD AVE
SOUTH DAYTONA, FL 32119

ISSUED


NOT FOR CONSTRUCTION

M&H NO.: 1000717-222018.01
DATE: JUNE 2025
DESIGNED BY: RJG
DRAWN BY: RJG
CHECKED BY: DAK
DO NOT SCALE DRAWINGS

SHEET CONTENTS
LIGHTING DETAILS

SHEET NO.

C-110

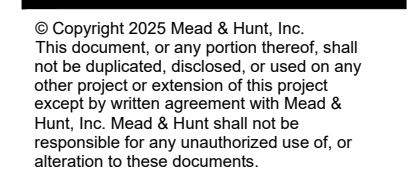

ISSUED

M&H NO.: 1000717-222018.01

DATE: JUNE 2025
DESIGNED BY: RJG
DRAWN BY: RJG
CHECKED BY: DAK
DO NOT SCALE DRAWINGS

SHEET CONTENTS

MOT DETAILS

SHEET NO.

C-112

GENERAL NOTES:

1. Use this Index only when called for in the Plans.
2. L = Taper Length
 B = Buffer Length
 X = Work Zone Sign Distance
See Index 102-600 for "L", "B", "X", channelizing device spacing values.
3. Provide a minimum 5'-0" wide bicycle path.
4. The "Speeding Fines Doubled When Workers Present" signs (MOT-13-06) and "End Road Work" signs (G20-2), along with associated work zone sign distances, may be omitted when the work operation will be in place for 24 hours or less.
5. Include additional signage at intersections as required by the Engineer or shown in the Plans.

SYMBOLS:

	Work Area
	Channelizing Device (See Index 102-600)
	Work Zone Sign
	Type III Barricade
	Lane Identification and Direction of Traffic

1. Temporary pavement markings may be omitted when the work operation is in place for 3 days or less.
2. If the Closed Bicycle Facility is a marked bicycle lane, use sign W20-5b instead of sign W21-5a.
3. If the travel lane is less than 14' wide, use sign R4-11.


Work Area
 Temporary Bicycle Way
 Channelizing Device (See Index 102-600)
 Work Zone Sign
 Arrow Board
 Lane Identification and Direction of Traffic

(1) PCMS=Portable Changeable
 (Variable) Message Sign

TYPICAL PCMS DISPLAY:
 Message 1: BICYCLE FACILITY CLOSED
 Message 2: BICYCLES IN ROAD

LAST REVISION 11/01/24	DESCRIPTION:  FY 2025-26 STANDARD PLANS	BICYCLE FACILITY CLOSURES	INDEX 102-661	SHEET 2 of 2
------------------------------	--	---------------------------	------------------	-----------------

\\CORP.MEADHUNT.COM\SHARED\FOLDERS\ENTR1000717\222018.01\TECH\CAD\DRAWINGS\PHOTOMETRICS.DWG 6/19/2025 9:21:29 AM

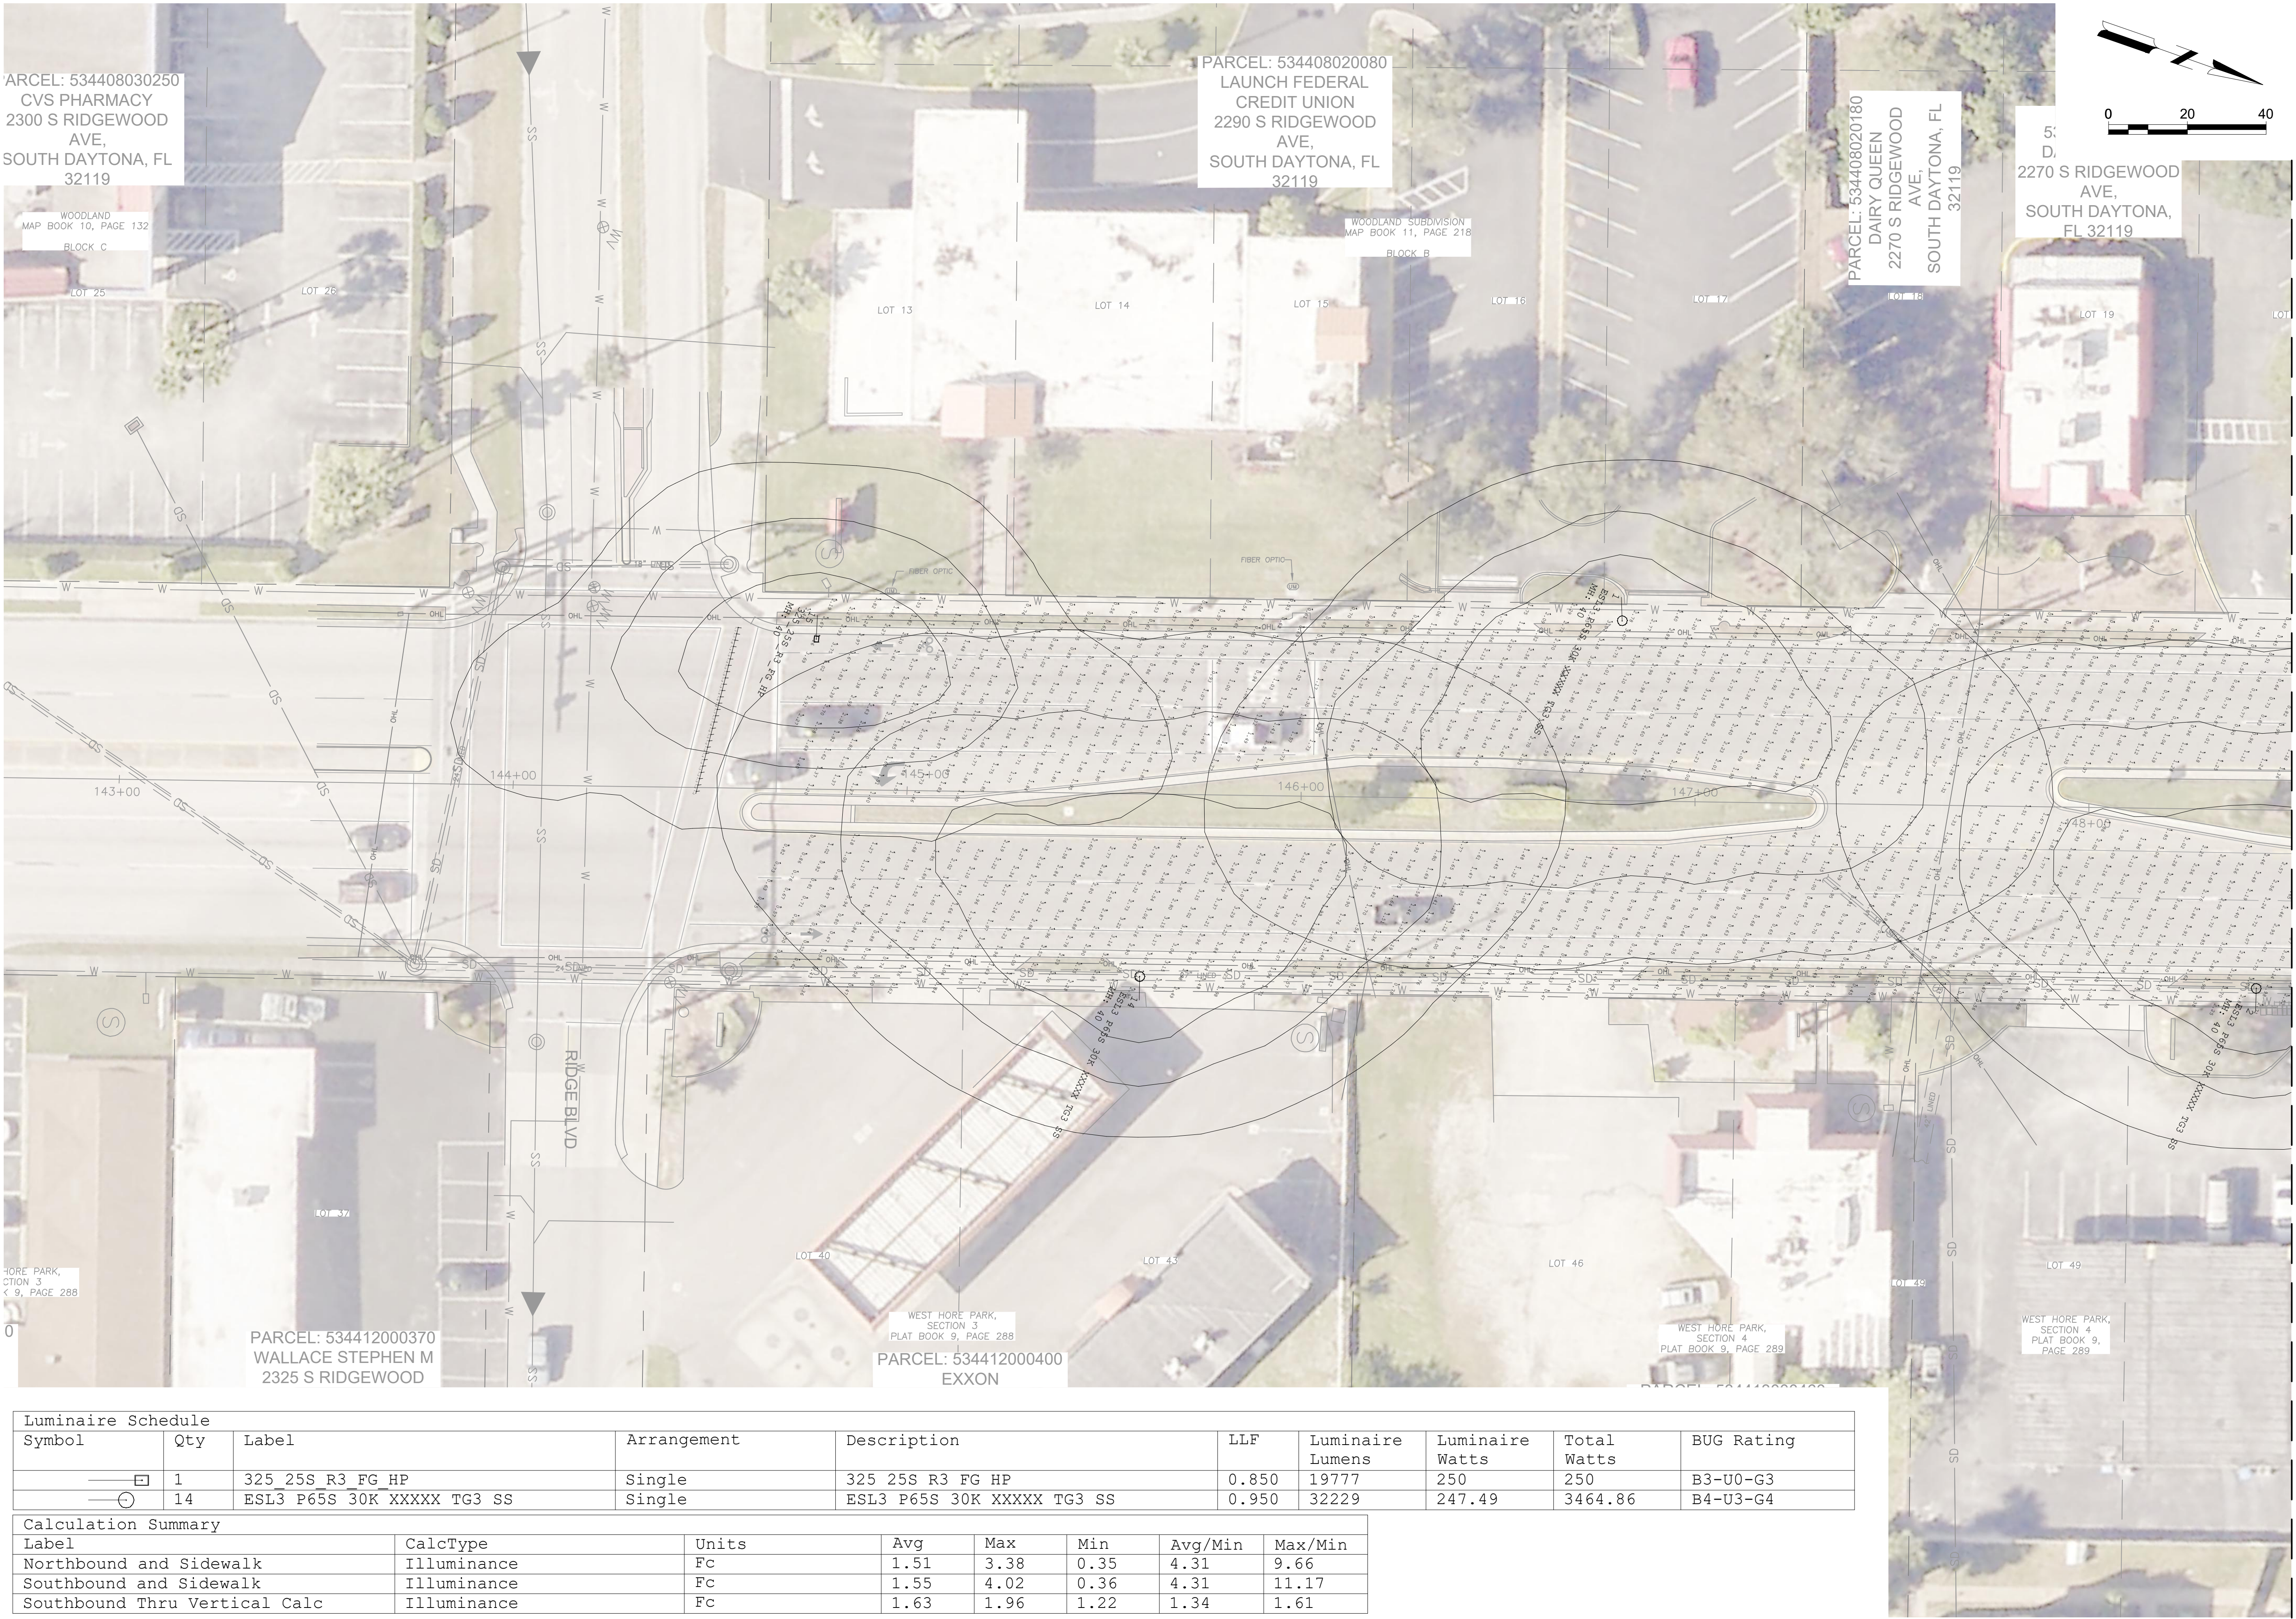

Luminaire Schedule									
Symbol	Qty	Label	Arrangement	Description	LLF	Luminaire Lumens	Luminaire Watts	Total Watts	BUG Rating
	1	325 25S R3 FG HP	Single	325 25S R3 FG HP	0.850	19777	250	250	B3-U0-G3
	14	ESL3 P65S 30K XXXXX TG3 SS	Single	ESL3 P65S 30K XXXXX TG3 SS	0.950	32229	247.49	3464.86	B4-U3-G4

Calculation Summary								
Label	CalcType	Units	Avg	Max	Min	Avg/Min	Max/Min	
Northbound and Sidewalk	Illuminance	Fc	1.51	3.38	0.35	4.31	9.66	
Southbound and Sidewalk	Illuminance	Fc	1.55	4.02	0.36	4.31	11.17	
Southbound Thru Vertical Calc	Illuminance	Fc	1.63	1.96	1.22	1.34	1.61	

Mead & Hunt

Mead and Hunt, Inc.
4401 Eastport Parkway
Port Orange, FL 32127
phone: 386-761-6810
meadhunt.com
FL Cert. #26730

SOUTH DAYTONA
SMALL CITY. BIG POSSIBILITIES.

© Copyright 2025 Mead & Hunt, Inc.
This document, or any portion thereof, shall not be duplicated, disclosed, or used on any other project or extension of this project except by written agreement with Mead & Hunt, Inc. Mead & Hunt shall not be responsible for any unauthorized use of, or alteration to these documents.

CITY OF SOUTH DAYTONA
US-1 UNDERGROUNDING
PH 2
S RIDGEWOOD AVE
SOUTH DAYTONA, FL 32119

ISSUED

MATCH LINE SEE SHEET E-205

NOT FOR CONSTRUCTION


M&H NO.: 1000717-222018.01
DATE: JUNE 2025
DESIGNED BY: RJG
DRAWN BY: RJG
CHECKED BY: DAK
DO NOT SCALE DRAWINGS

SHEET CONTENTS
PHOTOMETRICS

SHEET NO.

P-200

MATCH LINE SEE SHEET E-204

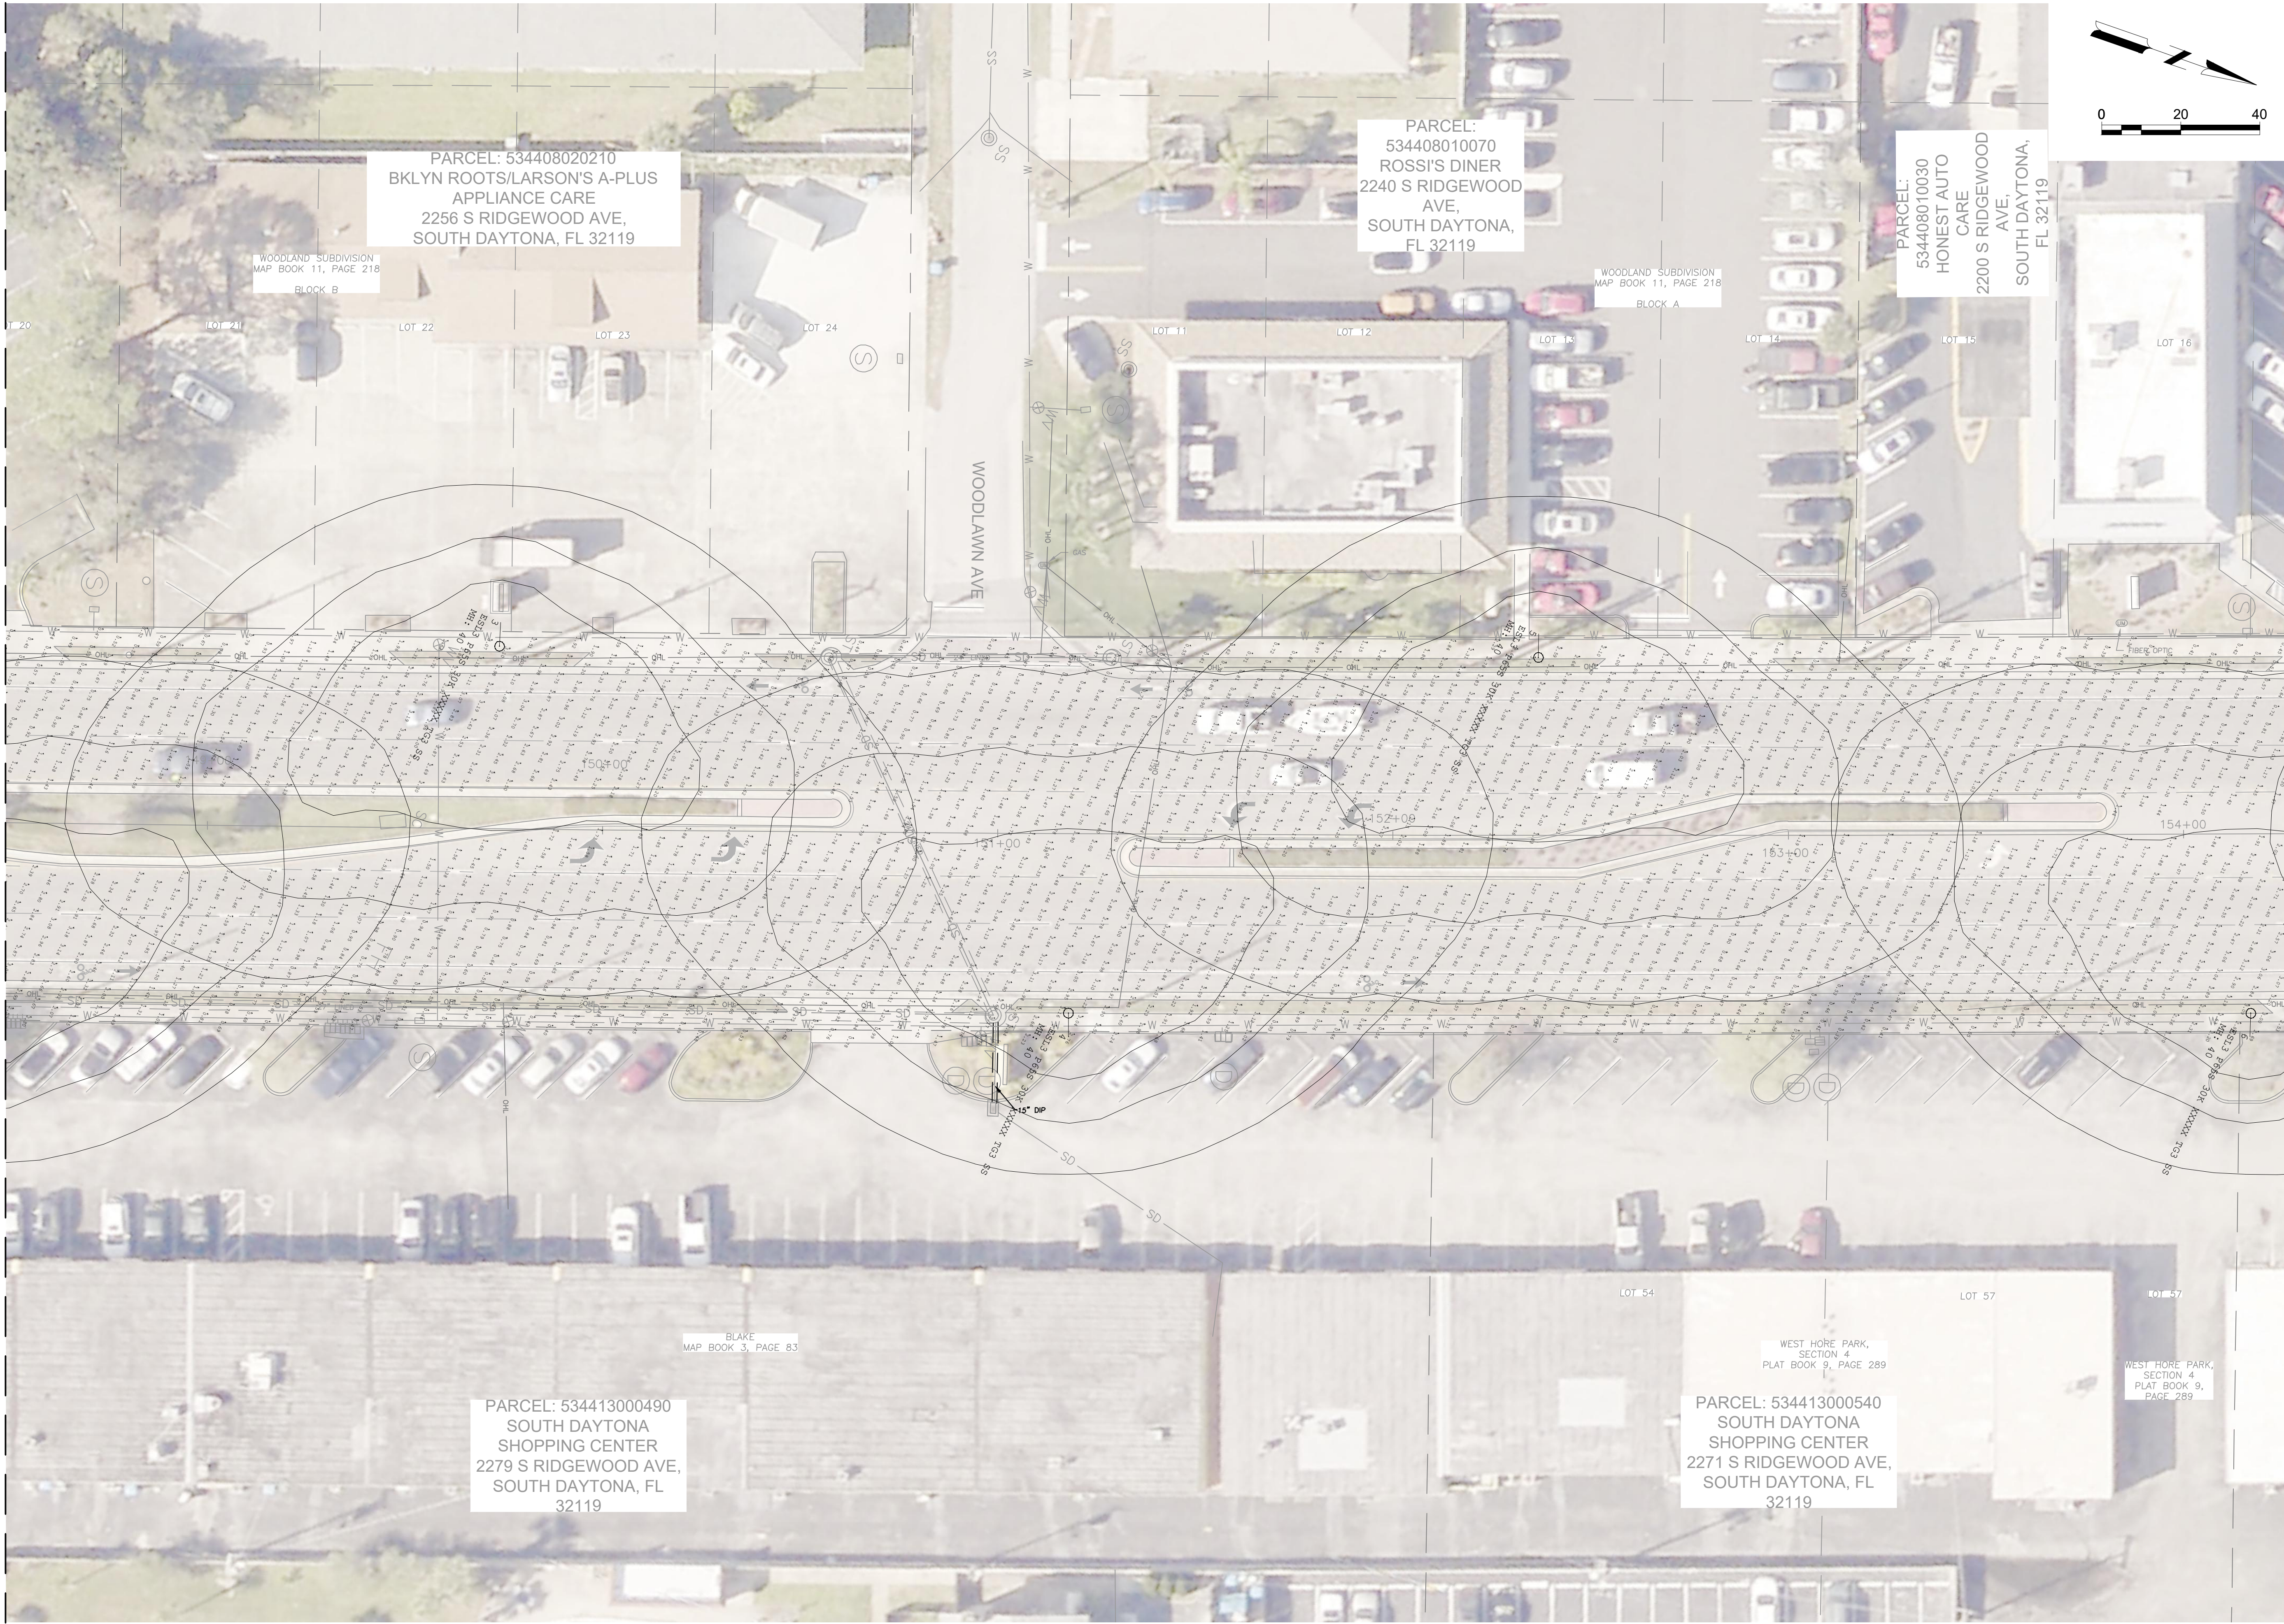

WOODLAND SUBDIVISION
MAP BOOK 11, PAGE 218
BLOCK B

PARCEL: 534408020210
BKLYN ROOTS/LARSON'S A-PLUS
APPLIANCE CARE
2256 S RIDGEWOOD AVE,
SOUTH DAYTONA, FL 32119

BLAKE
MAP BOOK 3, PAGE 83

PARCEL: 534413000490
SOUTH DAYTONA
SHOPPING CENTER
2279 S RIDGEWOOD AVE,
SOUTH DAYTONA, FL
32119

PARCEL:
534408010070
ROSSI'S DINER
2240 S RIDGEWOOD
AVE,
SOUTH DAYTONA,
FL 32119


WOODLAND SUBDIVISION
MAP BOOK 11, PAGE 218
BLOCK A

PARCEL:
534408010030
HONEST AUTO
CARE
2200 S RIDGEWOOD
AVE,
SOUTH DAYTONA,
FL 32119

WEST HORE PARK,
SECTION 4
PLAT BOOK 9, PAGE 289

PARCEL: 534413000540
SOUTH DAYTONA
SHOPPING CENTER
2271 S RIDGEWOOD AVE,
SOUTH DAYTONA, FL
32119

WEST HORE PARK,
SECTION 4
PLAT BOOK 9,
PAGE 289

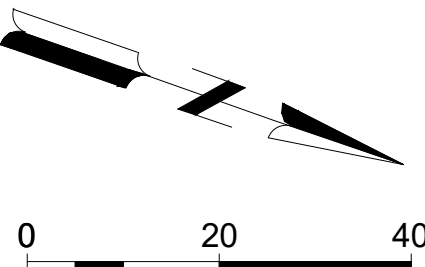

MATCH LINE SEE SHEET E-206

CITY OF SOUTH DAYTONA
US-1 UNDERGROUNDING
PH 2

S RIDGEWOOD AVE
SOUTH DAYTONA, FL 32119

ISSUED

NOT FOR CONSTRUCTION

M&H NO.: 1000717-222018.01
DATE: JUNE 2025
DESIGNED BY: RJG
DRAWN BY: RJG
CHECKED BY: DAK
DO NOT SCALE DRAWINGS

SHEET CONTENTS
PHOTOMETRICS

SHEET NO.

P-201

Mead & Hunt
Mead and Hunt, Inc.
4401 Eastport Parkway
Port Orange, FL 32127
phone: 386-761-6810
meadhunt.com
FL Cert. #26730

© Copyright 2025 Mead & Hunt, Inc.
This document, or any portion thereof, shall not be duplicated, disclosed, or used on any other project or extension of this project except by written agreement with Mead & Hunt, Inc. Mead & Hunt shall not be responsible for any unauthorized use of, or alteration to these documents.

MATCH LINE SEE SHEET E-207

MATCH LINE SEE SHEET E-206




PARCEL: 534416000515
PUSWALD PLAZA
2100 S RIDGEWOOD
AVE,
SOUTH DAYTONA,
FL 32119

TOWN OF BLAKE
MAP BOOK 15, PAGE 119
LOT 51A

PARCEL: 534416000521
RIDGE APTS LLC
2050 S RIDGEWOOD
AVE,
SOUTH DAYTONA,
FL 32119

TOWN OF BLAKE
MAP BOOK 15, PAGE 119
LOT 52

PARCEL: 534416000522
CER-BURG
ENTERPRISES INC
2040 S RIDGEWOOD
AVE,
SOUTH DAYTONA, FL
32119

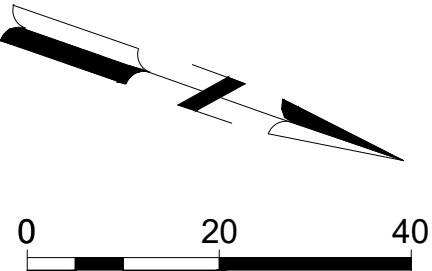

Mead
& Hunt

Mead and Hunt, Inc.
4401 Eastport Parkway
Port Orange, FL 32127
phone: 386-761-6810
meadhunt.com
FL Cert. #26730



© Copyright 2025 Mead & Hunt, Inc.
This document, or any portion thereof, shall
not be duplicated, disclosed, or used on any
other project or extension of this project
except by written agreement with Mead &
Hunt, Inc. Mead & Hunt shall not be
responsible for any unauthorized use of, or
alteration to these documents.

CITY OF SOUTH DAYTONA
US-1 UNDERGROUNDING
PH 2
S RIDGEWOOD AVE
SOUTH DAYTONA, FL 32119

ISSUED



NOT FOR CONSTRUCTION

M&H NO.: 1000717-222018.01
DATE: JUNE 2025
DESIGNED BY: RJG
DRAWN BY: RJG
CHECKED BY: DAK
DO NOT SCALE DRAWINGS

SHEET CONTENTS
PHOTOMETRICS

SHEET NO.

P-203

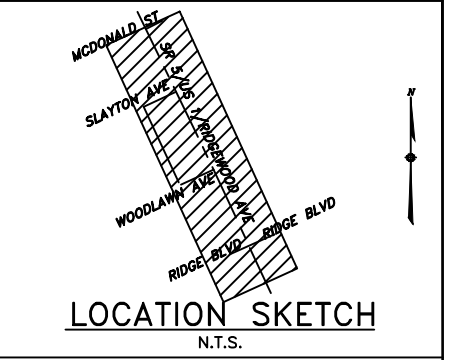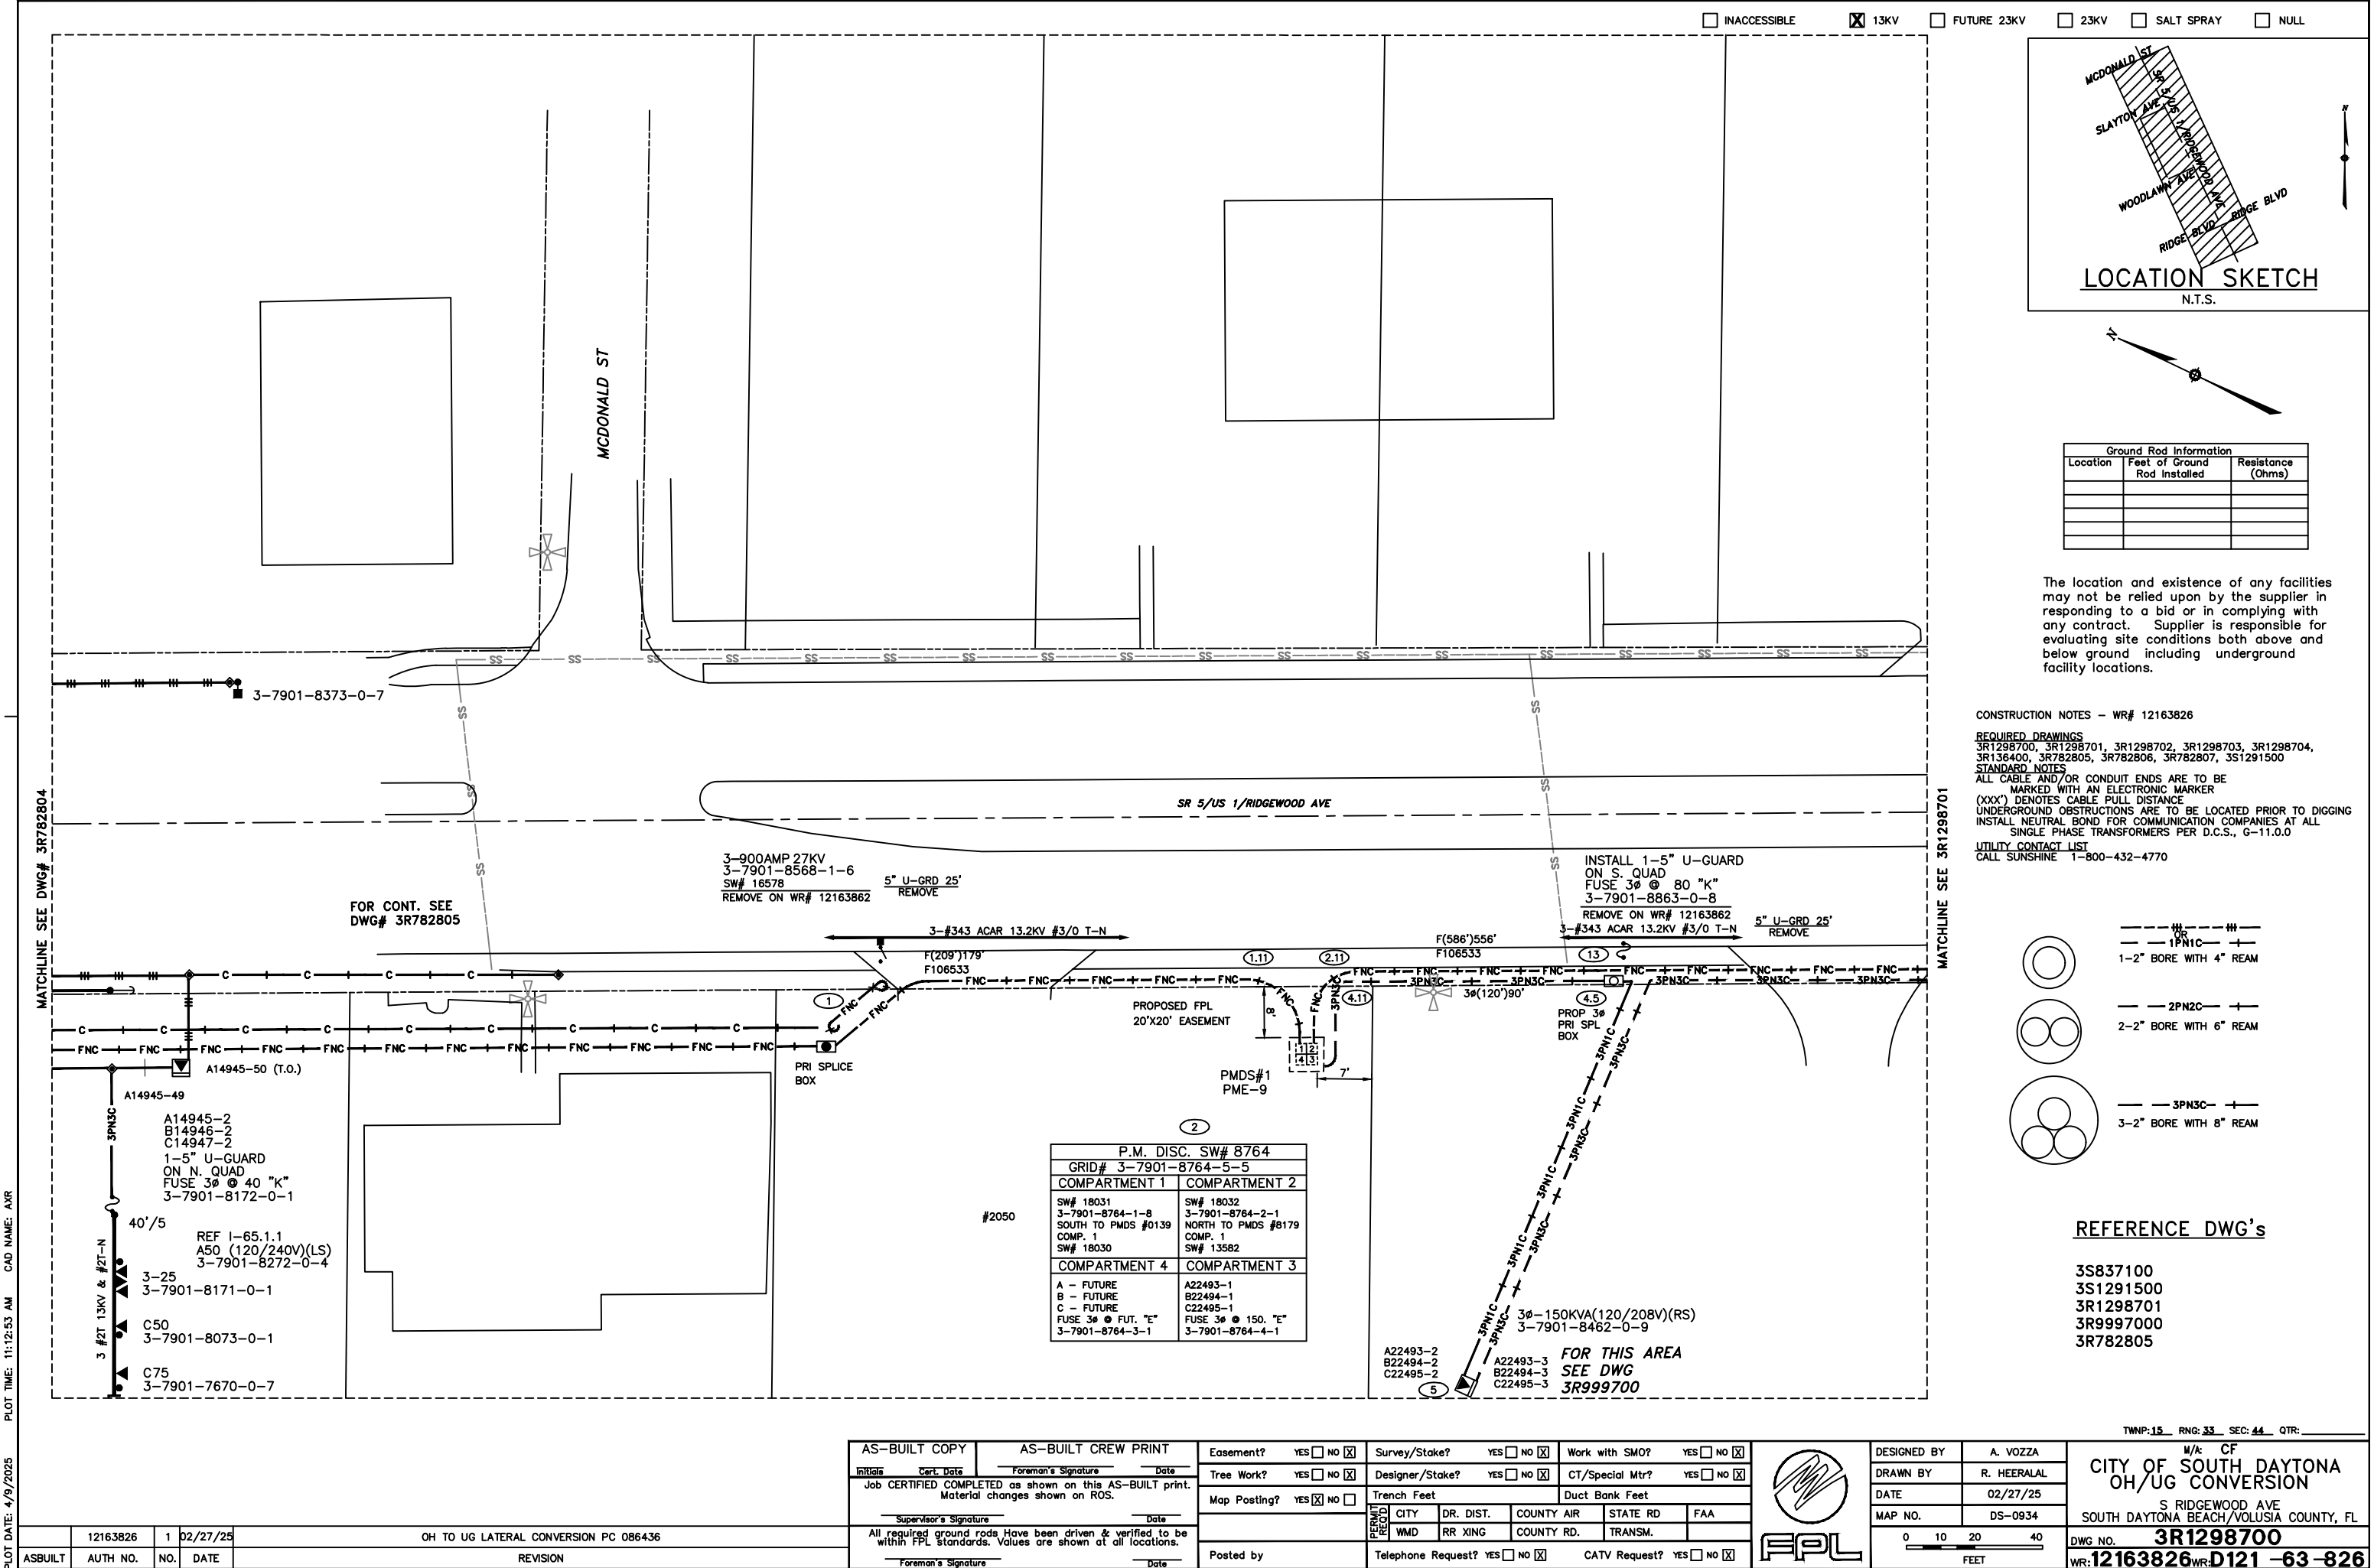


Ground Rod Information		
Location	Feet of Ground Rod Installed	Resistance (Ohms)

The location and existence of any facilities may not be relied upon by the supplier in responding to a bid or in complying with any contract. Supplier is responsible for evaluating site conditions both above and below ground including underground facility locations.

CONSTRUCTION NOTES - WR# 12163826

REQUIRED DRAWINGS
3R1298700, 3R1298701, 3R1298702, 3R1298703, 3R1298704, 3R136400, 3R782805, 3R782806, 3R782807, 3S1291500
STANDARD NOTES
ALL CABLE AND/OR CONDUIT ENDS ARE TO BE MARKED WITH AN ELECTRONIC MARKER
(XXX') DENOTES CABLE PULL DISTANCE
UNDERGROUND OBSTRUCTIONS ARE TO BE LOCATED PRIOR TO DIGGING
INSTALL NEUTRAL BOND FOR COMMUNICATION COMPANIES AT ALL SINGLE PHASE TRANSFORMERS PER D.C.S., G-11.0.0
UTILITY CONTACT LIST
CALL SUNSHINE 1-800-432-4770

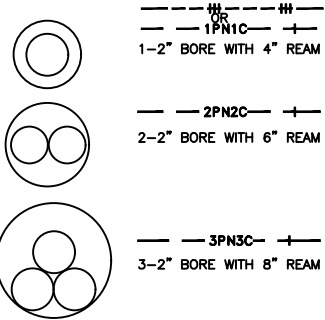

REFERENCE DWG's

3S837100
3S1291500
3R1298701
3R9997000
3R782805

PLOT DATE: 4/9/2025 PLOT TIME: 11:12:53 AM CAD NAME: AXR

12163826 1 02/27/25 OH TO UG LATERAL CONVERSION PC 086436

ASBUILT	AUTH NO.	NO.	DATE	REVISION



AS-BUILT COPY		AS-BUILT CREW PRINT	
Initials	Cert. Date	Foreman's Signature	Date
Job CERTIFIED COMPLETED as shown on this AS-BUILT print. Material changes shown on ROS.			
Supervisor's Signature		Date	
All required ground rods Have been driven & verified to be within FPL standards. Values are shown at all locations.			
Foreman's Signature		Date	

Easement?	YES ☐ NO ☒	Survey/Stake?	YES ☐ NO ☒	Work with SMO?	YES ☐ NO ☒
Tree Work?	YES ☐ NO ☒	Designer/Stake?	YES ☐ NO ☒	CT/Special Mtr?	YES ☐ NO ☒
Map Posting?	YES ☒ NO ☐	Trench Feet	Duct Bank Feet		
Posted by		Telephone Request?	YES ☐ NO ☒	CATV Request?	YES ☐ NO ☒



DESIGNED BY	A. VOZZA
DRAWN BY	R. HEERALAL
DATE	02/27/25
MAP NO.	DS-0934

CITY OF SOUTH DAYTONA OH/UG CONVERSION	
S RIDGEWOOD AVE SOUTH DAYTONA BEACH/VOLUSIA COUNTY, FL	
DWG NO.	3R1298700
WR:	12163826WR: D121 -63 -826

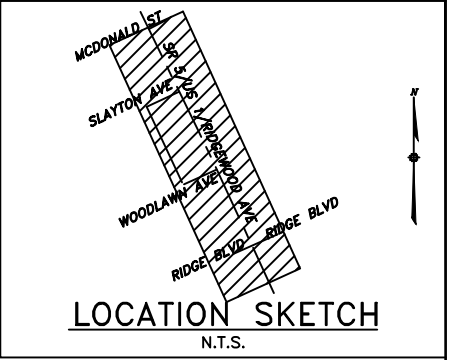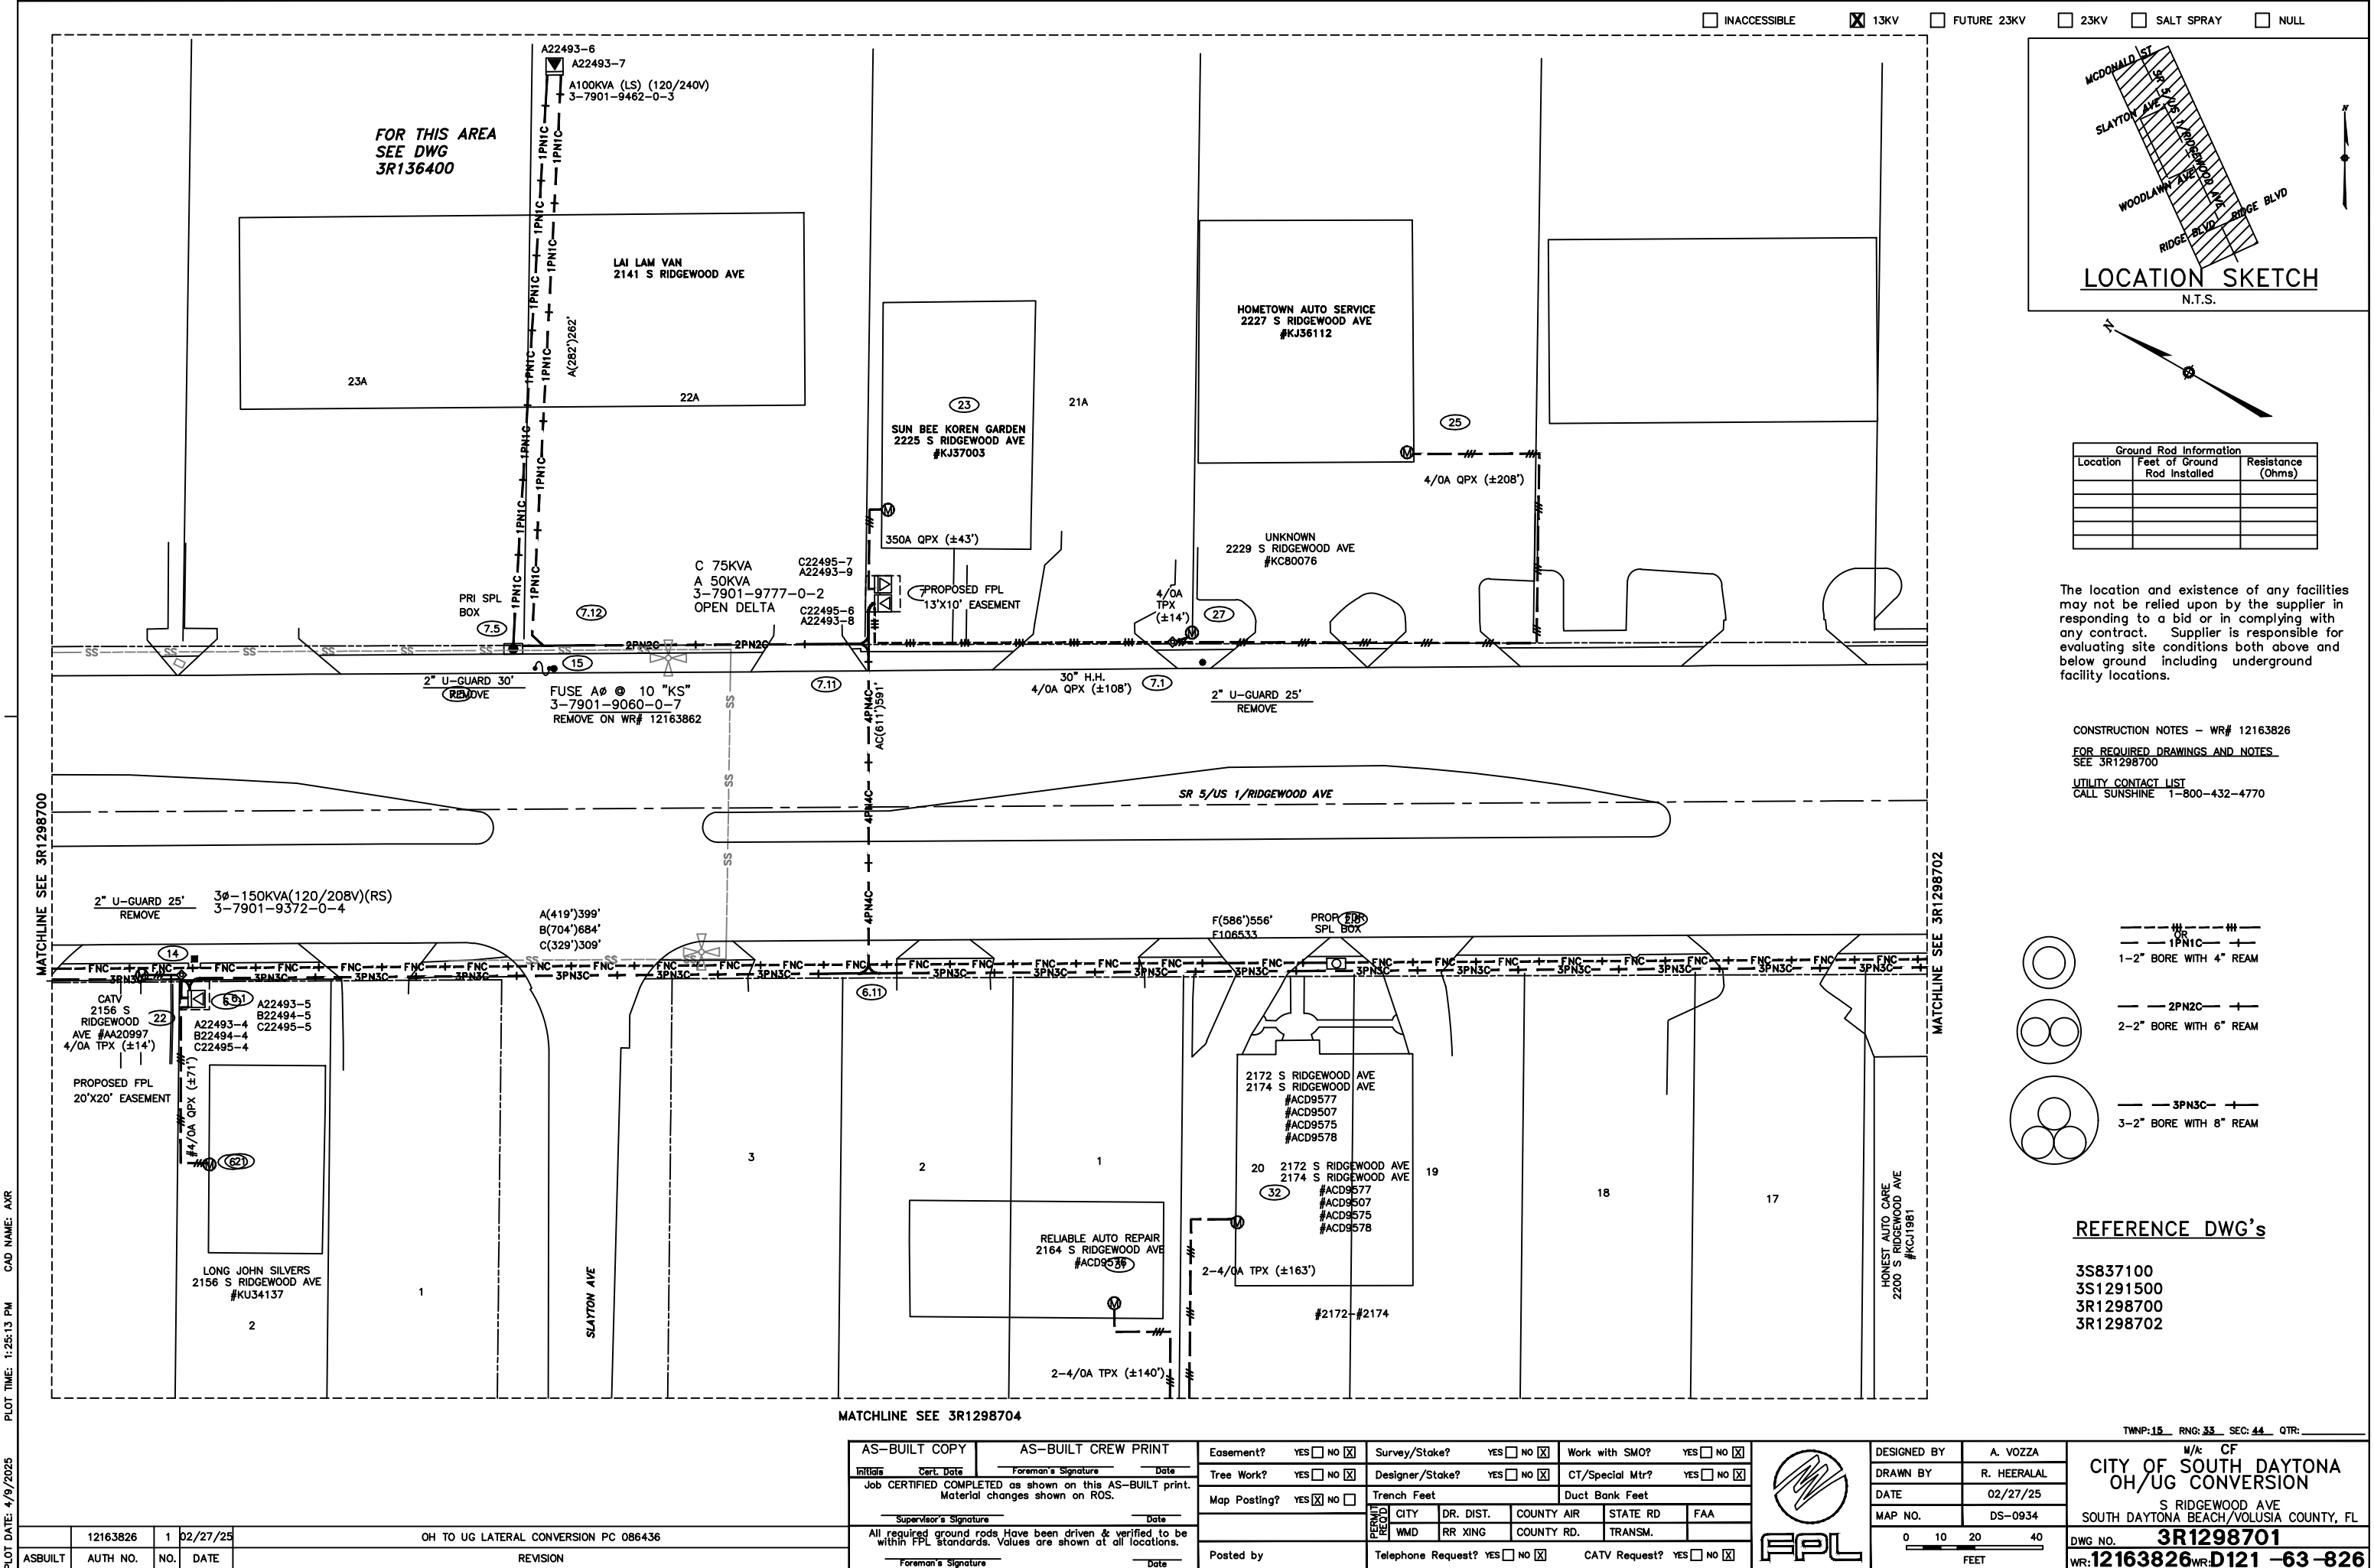


Ground Rod Information		
Location	Feet of Ground Rod Installed	Resistance (Ohms)

The location and existence of any facilities may not be relied upon by the supplier in responding to a bid or in complying with any contract. Supplier is responsible for evaluating site conditions both above and below ground including underground facility locations.

CONSTRUCTION NOTES - WR# 12163826

FOR REQUIRED DRAWINGS AND NOTES SEE 3R1298700

UTILITY CONTACT LIST CALL SUNSHINE 1-800-432-4770

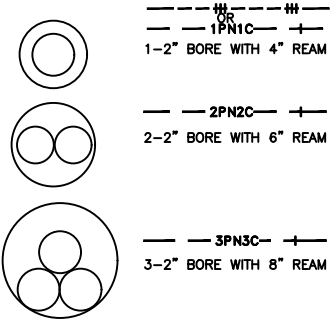

REFERENCE DWG's

3S837100
3S1291500
3R1298700
3R1298702

TWNP: 15 RING: 33 SEC: 44 QTR:

AS-BUILT COPY		AS-BUILT CREW PRINT	
Initials	Cert. Date	Foreman's Signature	Date
Job CERTIFIED COMPLETED as shown on this AS-BUILT print. Material changes shown on ROS.			
Supervisor's Signature		Date	
All required ground rods have been driven & verified to be within FPL standards. Values are shown at all locations.			
Foreman's Signature		Date	

Easement?	YES ☐ NO ☒	Survey/Stake?	YES ☐ NO ☒	Work with SMO?	YES ☐ NO ☒
Tree Work?	YES ☐ NO ☒	Designer/Stake?	YES ☐ NO ☒	CT/Special Mtr?	YES ☐ NO ☒
Map Posting?	YES ☒ NO ☐	Trench Feet	Duct Bank Feet		
FPL RECORD	CITY	DR. DIST.	COUNTY AIR	STATE RD	FAA
	WMD	RR XING	COUNTY RD.	TRANSM.	
Posted by	Telephone Request?		YES ☐ NO ☒	CATV Request?	YES ☐ NO ☒





DESIGNED BY	A. VOZZA
DRAWN BY	R. HEERALAL
DATE	02/27/25
MAP NO.	DS-0934

CITY OF SOUTH DAYTONA OH/UG CONVERSION	
S RIDGEWOOD AVE SOUTH DAYTONA BEACH/VOLUSIA COUNTY, FL	
DWG NO.	3R1298701
WR:	12163826

PLOT DATE: 4/9/2025 PLOT TIME: 1:25:13 PM CAD NAME: AXR


ASBUILT	12163826	1	02/27/25	OH TO UG LATERAL CONVERSION PC 086436
AUTH NO.	NO.	DATE	REVISION	

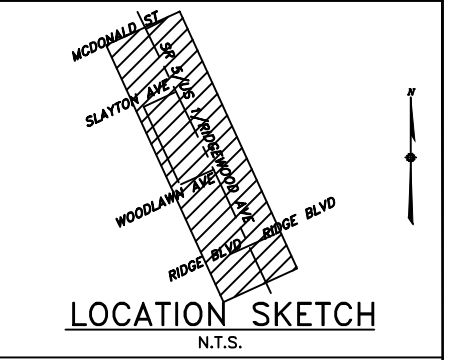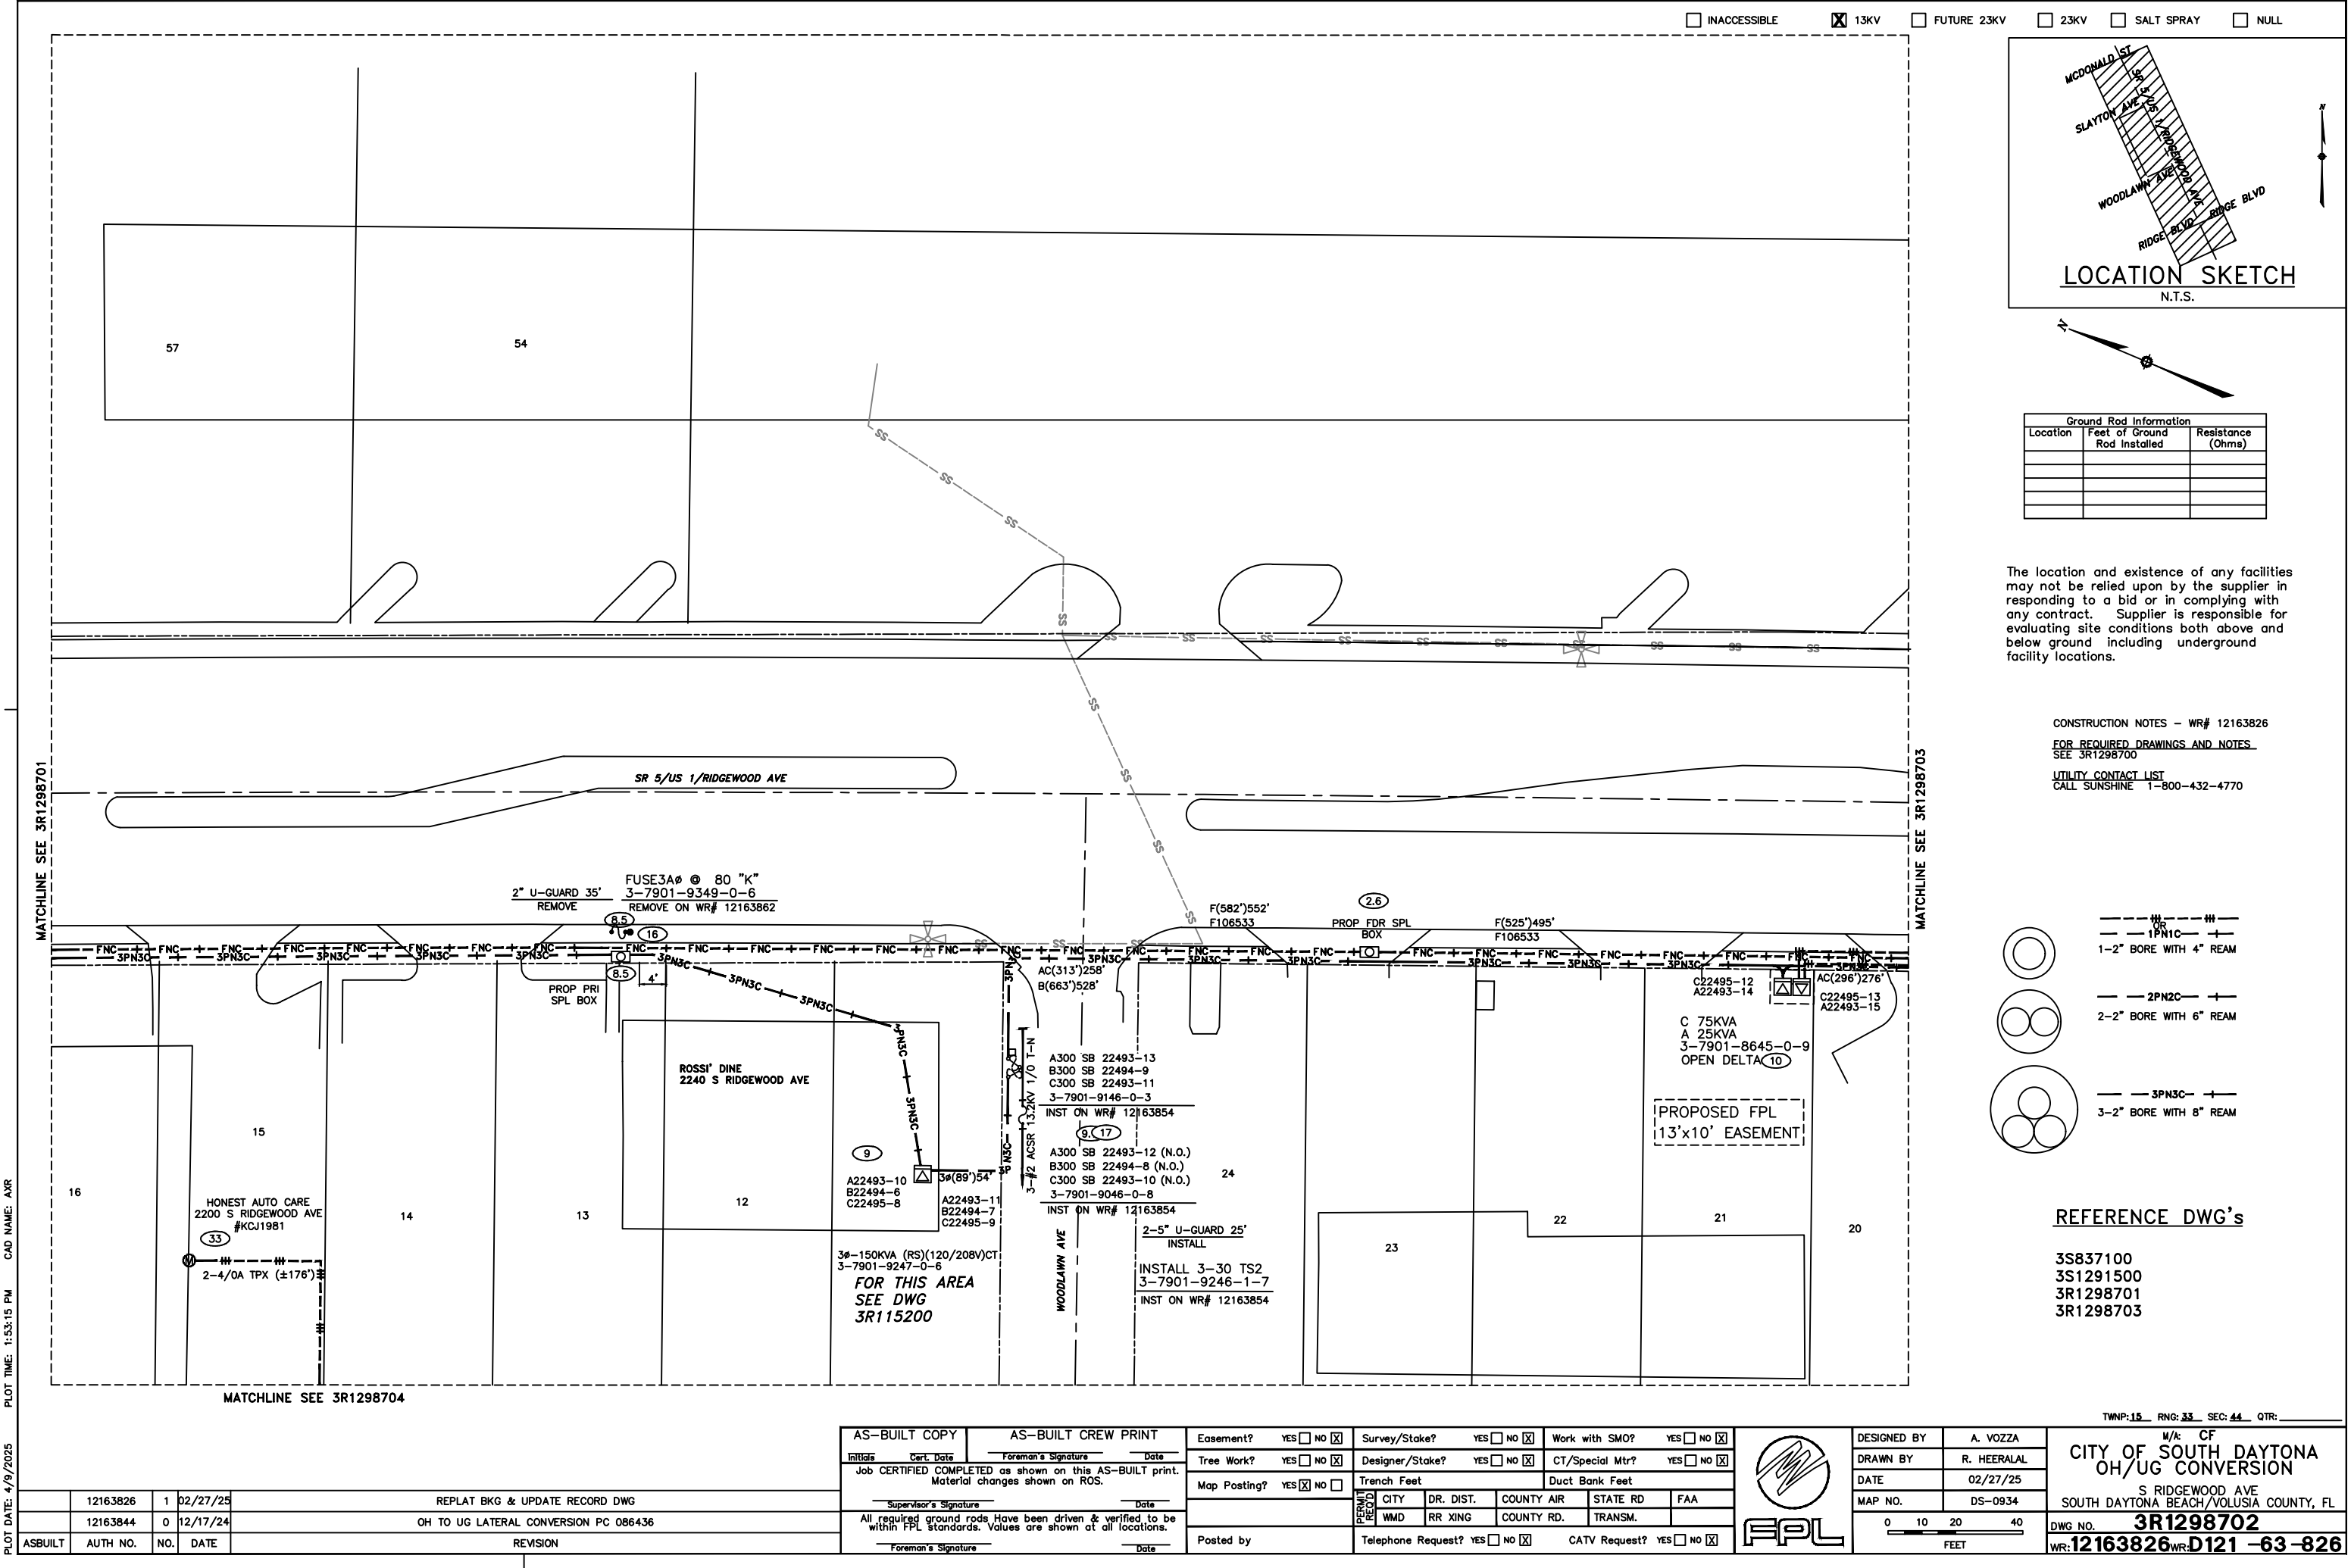

Ground Rod Information		
Location	Feet of Ground Rod Installed	Resistance (Ohms)

The location and existence of any facilities may not be relied upon by the supplier in responding to a bid or in complying with any contract. Supplier is responsible for evaluating site conditions both above and below ground including underground facility locations.

CONSTRUCTION NOTES - WR# 12163826
FOR REQUIRED DRAWINGS AND NOTES SEE 3R1298700
UTILITY CONTACT LIST
CALL SUNSHINE 1-800-432-4770

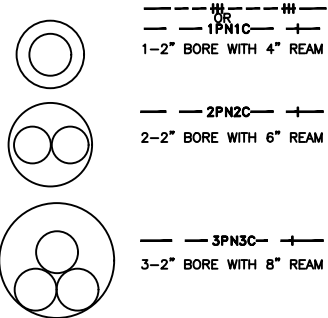


REFERENCE DWG's


3S837100
3S1291500
3R1298701
3R1298703

TWNP: 15 RING: 33 SEC: 44 QTR:

AS-BUILT COPY				AS-BUILT CREW PRINT				Easement? YES ☐ NO ☒				Survey/Stake? YES ☐ NO ☒				Work with SMO? YES ☐ NO ☒						DESIGNED BY		A. VOZZA		 CITY OF SOUTH DAYTONA OH/UG CONVERSION S RIDGEWOOD AVE SOUTH DAYTONA BEACH/VOLUSIA COUNTY, FL											
Initials				Foreman's Signature				Tree Work? YES ☐ NO ☒				Designer/Stake? YES ☐ NO ☒				CT/Special Mtr? YES ☐ NO ☒						DRAWN BY		R. HEERALAL													
Job CERTIFIED COMPLETED as shown on this AS-BUILT print. Material changes shown on ROS.				Supervisor's Signature				Map Posting? YES ☒ NO ☐				Trench Feet				Duct Bank Feet						DATE		02/27/25													
All required ground rods have been driven & verified to be within FPL standards. Values are shown at all locations.				Foreman's Signature				Posted by				Telephone Request? YES ☐ NO ☒				CATV Request? YES ☐ NO ☒						MAP NO.		DS-0934													
12163826				1				02/27/25				REPLAT BKG & UPDATE RECORD DWG												0		10		20		40		FEET		DWG NO.		3R1298702	
12163844				0				12/17/24				OH TO UG LATERAL CONVERSION PC 086436																				WR: 12163826		WR: D121 -63 -826			
ASBUILT				AUTH NO.				NO.				DATE				REVISION																					

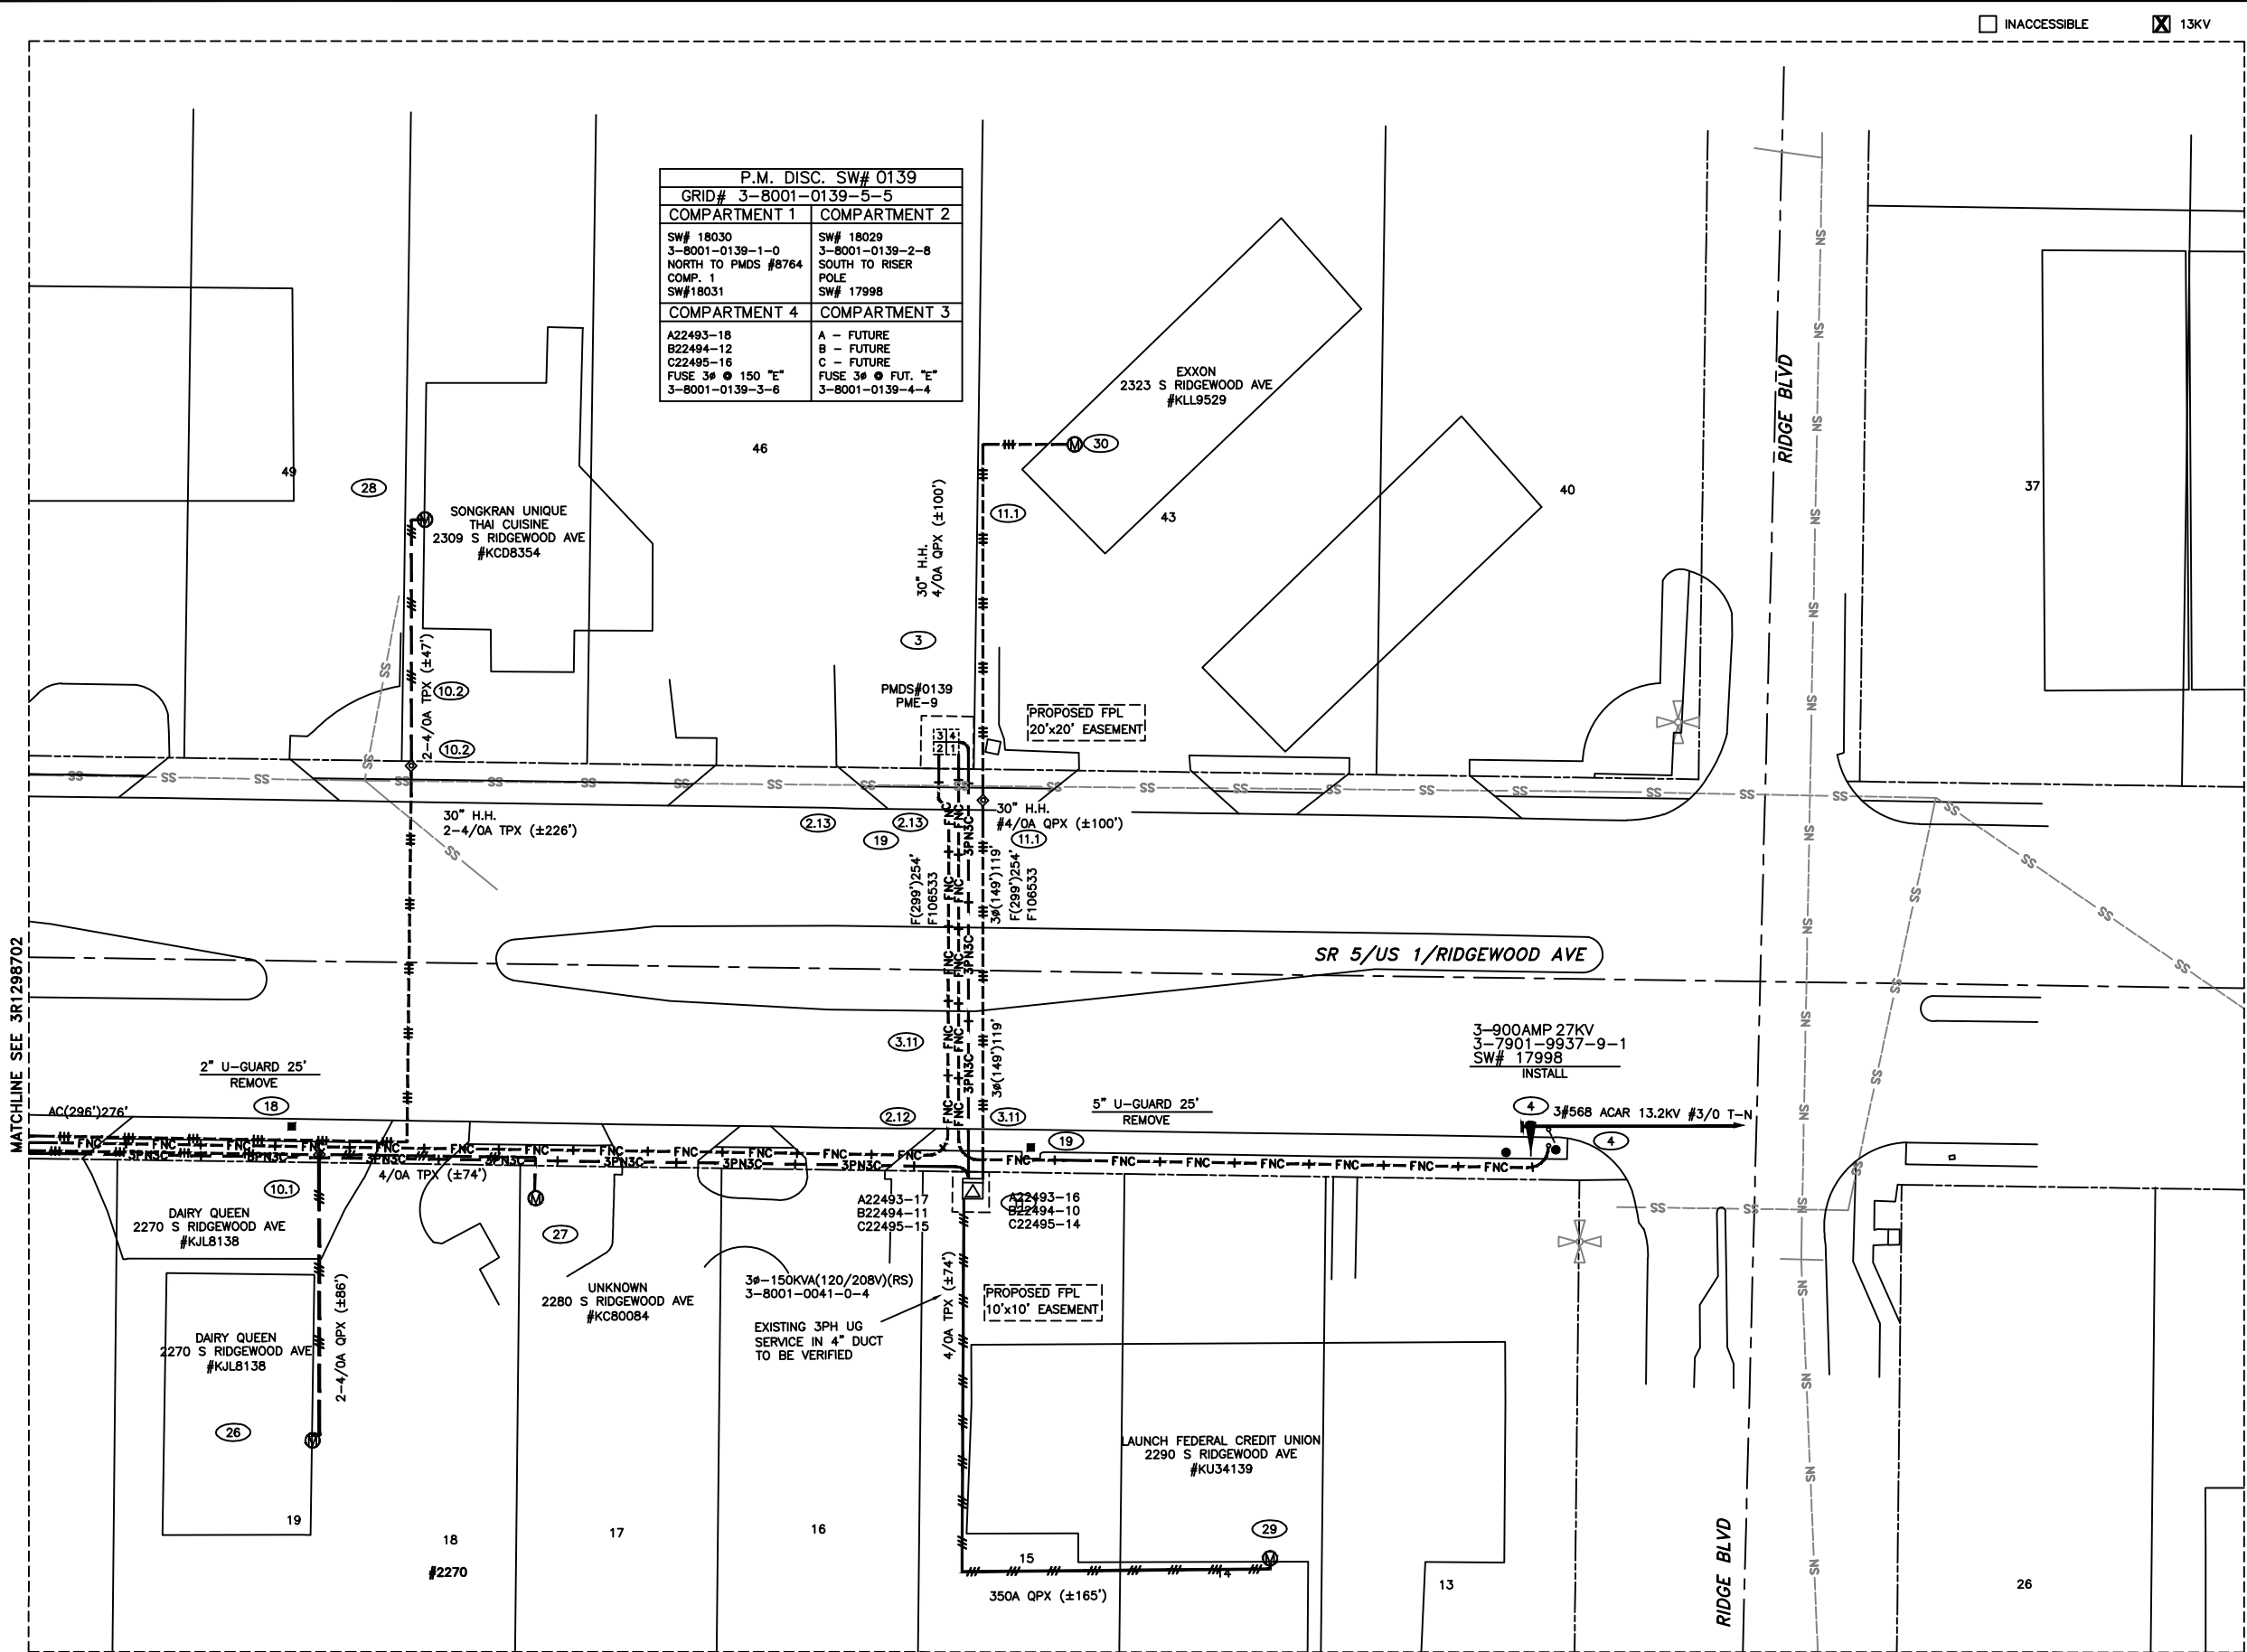

P.M. DISC. SW# 0139	
GRID# 3-8001-0139-5-5	
COMPARTMENT 1	COMPARTMENT 2
SW# 18030	SW# 18029
3-8001-0139-1-0	3-8001-0139-2-8
NORTH TO PMDS #8764	SOUTH TO RISER
COMP. 1	POLE
SW#18031	SW# 17998
COMPARTMENT 4	COMPARTMENT 3
A22493-18	A - FUTURE
B22494-12	B - FUTURE
C22495-16	C - FUTURE
FUSE 3# @ 150 "E"	FUSE 3# @ FUT. "E"
3-8001-0139-3-6	3-8001-0139-4-4

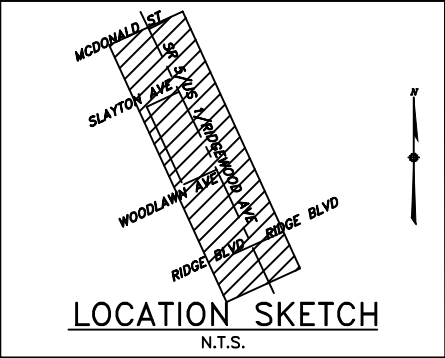


Ground Rod Information		
Location	Feet of Ground Rod Installed	Resistance (Ohms)

The location and existence of any facilities may not be relied upon by the supplier in responding to a bid or in complying with any contract. Supplier is responsible for evaluating site conditions both above and below ground including underground facility locations.

CONSTRUCTION NOTES - WR# 12163826

FOR REQUIRED DRAWINGS AND NOTES
SEE 3R1298700

UTILITY CONTACT LIST
CALL SUNSHINE 1-800-432-4770

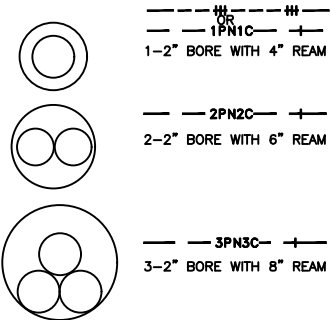

REFERENCE DWG's

3S837100
3S1291500
3R1298702

TWNP: 15 RING: 33 SEC: 44 QTR: 1

AS-BUILT COPY	AS-BUILT CREW PRINT
Initials	Foreman's Signature
Job CERTIFIED COMPLETED as shown on this AS-BUILT print. Material changes shown on ROS.	Date
Supervisor's Signature	Date
All required ground rods have been driven & verified to be within FPL standards. Values are shown at all locations.	Date
Foreman's Signature	Date


Easement?	YES ☐ NO ☒	Survey/Stake?	YES ☐ NO ☒	Work with SMO?	YES ☐ NO ☒
Tree Work?	YES ☐ NO ☒	Designer/Stake?	YES ☐ NO ☒	CT/Special Mtr?	YES ☐ NO ☒
Map Posting?	YES ☒ NO ☐	Trench Feet		Duct Bank Feet	
Posted by		Telephone Request?	YES ☐ NO ☒	CATV Request?	YES ☐ NO ☒



DESIGNED BY	A. VOZZA
DRAWN BY	R. HEERALAL
DATE	02/27/25
MAP NO.	DS-0934

CITY OF SOUTH DAYTONA	
OH/UG CONVERSION	
S RIDGEWOOD AVE	
SOUTH DAYTONA BEACH/VOLUSIA COUNTY, FL	
DWG NO.	3R1298703
WR:	12163826WR: D121 -63-826

ASBUILT	12163826	1	02/27/25	OH TO UG LATERAL CONVERSION PC 086436
AUTH NO.	NO.	DATE	REVISION	

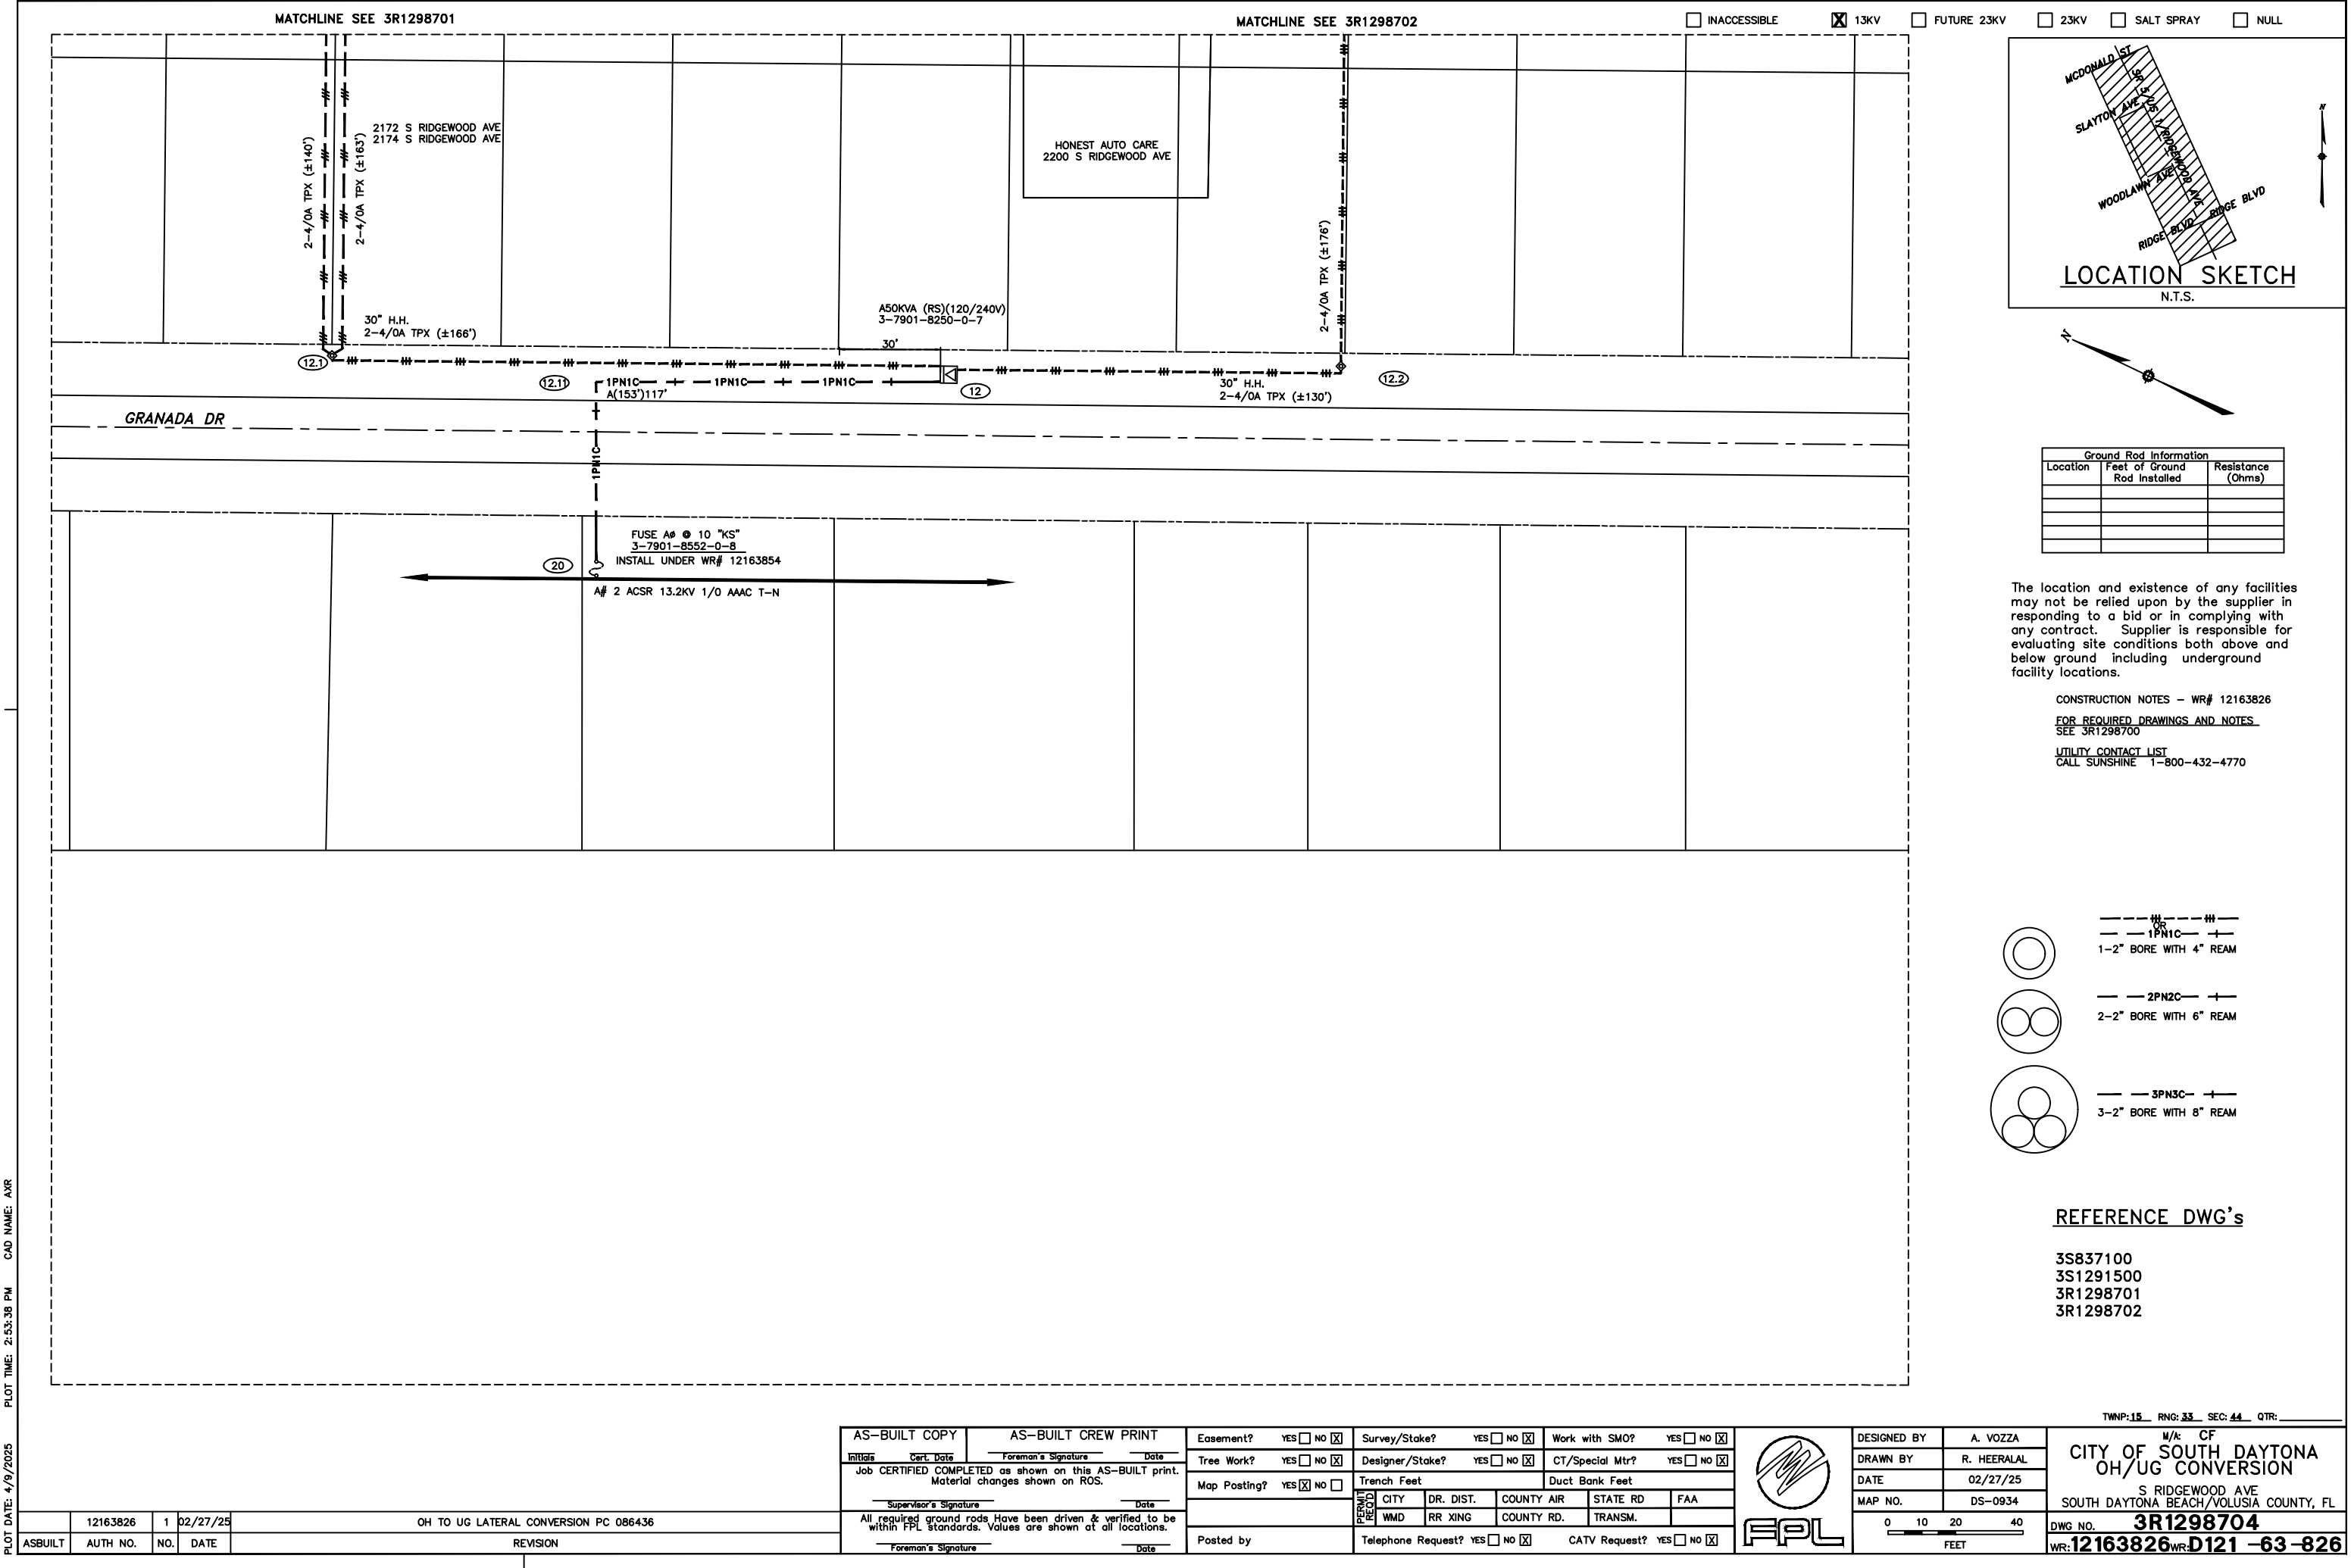

INACCESSIBLE

13KV

FUTURE 23KV

23KV

SALT SPRAY

NULL

LOCATION SKETCH

N.T.S.

Ground Rod Information

Location	Feet of Ground Rod Installed	Resistance (Ohms)

The location and existence of any facilities may not be relied upon by the supplier in responding to a bid or in complying with any contract. Supplier is responsible for evaluating site conditions both above and below ground including underground facility locations.

CONSTRUCTION NOTES - WR# 12163826

FOR REQUIRED DRAWINGS AND NOTES SEE 3R1298700

UTILITY CONTACT LIST

CALL SUNSHINE 1-800-432-4770

1-2" BORE WITH 4" REAM

2-2" BORE WITH 6" REAM

3-2" BORE WITH 8" REAM

REFERENCE DWG's

3S837100

3S1291500

3R1298701

3R1298702

TWNP: 15

RNG: 33

SEC: 44

QTR:

AS-BUILT COPY

AS-BUILT CREW PRINT

Job CERTIFIED COMPLETED as shown on this AS-BUILT print. Material changes shown on ROS.

All required ground rods Have been driven & verified to be within FPL standards. Values are shown at all locations.

Easement?

Tree Work?

Map Posting?

Posted by

Survey/Stake?

Designer/Stake?

Trench Feet

Telephone Request?

Work with SMO?

CT/Special Mtr?

Duct Bank Feet

CATV Request?

DESIGNED BY

DRAWN BY

DATE

MAP NO.

A. VOZZA

R. HEERALAL

02/27/25

DS-0934

CITY

DR. DIST.

COUNTY AIR

STATE RD

FAA

WMD

RR XING

COUNTY RD.

TRANSM.

0

10

20

40

FEET

CITY OF SOUTH DAYTONA

OH/UG CONVERSION

S RIDGEWOOD AVE

SOUTH DAYTONA BEACH/VOLUSIA COUNTY, FL

DWG NO.

3R1298704

WR: 12163826


121 -63 -826

PLOT DATE: 4/9/2025

PLOT TIME: 2:53:38 PM

CAD NAME: AXR

UTILITY CONTACT LIST
CALL SUNSHINE 1-800-432-4770

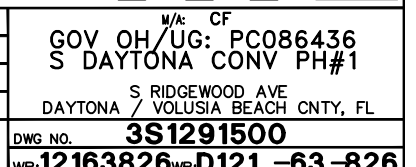

Easement?	YES ☐ NO ☒	Survey/State?	YES ☐ NO ☒	Work with SMO?	YES ☐ NO ☒	
Tree Work?	YES ☐ NO ☒	Designer/State?	YES ☐ NO ☒	CT/Special Mtr?	YES ☐ NO ☒	
Map Posting?	YES ☒ NO ☐	Trench Feet		Duct Bank Feet		
	PERMIT RECORD	CITY	DR. DIST.	COUNTY AIR	STATE RD	FAA
		WMD	RR XING	COUNTY RD.	TRANSM.	
Posted by		Telephone Request? YES ☐ NO ☒		CATV Request? YES ☐ NO ☒		

INACCESSIBLE 13KV FUTURE 23KV 23KV SALT SPRAY ROCK

The location and existence of any facilities may not be relied upon by the supplier in responding to a bid or in complying with any contract. Supplier is responsible for evaluating site conditions both above and below ground including underground facility locations.

CONSTRUCTION NOTES - WR# 12163826
FOR NOTES & REQUIRED DWGS
SEE 3R782805
UTILITY CONTACT LIST
CALL SUNSHINE 1-800-432-4770

REFERENCE DWG's

3R782800
3R782801
3R782802
3R782804
3S1291500

TWNP: 15 RING: 33 SEC: 44 QTR:

PLOT DATE: 4/9/2025 PLOT TIME: 3:08:45 PM CAD NAME: AXR

	12163826	13	04/09/25	S DAYTONA - RIDGEWOOD AVE. CONV PH # 1
	13763591	12	01/14/25	REPLACE PMDS #1 LIKE FOR LIKE
	13763371	11	01/14/25	REPLACE PMDS #3 LIKE FOR LIKE
	12024565	9	12/28/22	REPLACE PMDS #5 LIKE FOR LIKE
06/11/07	1052184	0	08/12/05	(IPC) INST. PMTX'S, PH. SWITCHES, PMDS#1-6 FOR UG. RELOC. CITY OF S. DAYTONA ON US#1
ASBUILT	AUTH NO.	NO.	DATE	REVISION

AS-BUILT COPY		AS-BUILT CREW PRINT	
Initials	Cert. Date	Foreman's Signature	Date
Job CERTIFIED COMPLETED as shown on this AS-BUILT print. Material changes shown on ROS.			
Supervisor's Signature	Date	Foreman's Signature	Date
All required ground rods have been driven & verified to be within FPL standards. Values are shown at all locations.			

Easement?	YES ☐ NO ☒	Survey/Stake?	YES ☐ NO ☒	Work with SMO?	YES ☐ NO ☒
Tree Work?	YES ☐ NO ☒	Designer/Stake?	YES ☐ NO ☒	CT/Special Mtr?	YES ☐ NO ☒
Map Posting?	YES ☒ NO ☐	Trench Feet	Duct Bank Feet		
Posted by		Telephone Request?	YES ☐ NO ☒	CATV Request?	YES ☐ NO ☒



DESIGNED BY	A. VOZZA
DRAWN BY	A. RAVELO
DATE	04/09/25
MAP NO.	DV-0937

M/C: CF	
CITY OF SOUTH DAYTONA	
OH/UG CONVERSION	
US HWY 1 & BEVILLE ROAD	
SOUTH DAYTONA / VOLUSIA COUNTY, FL	
DWG NO.	3S837100
WR:	12163826WR: D121 -63-826